


DOCKETED

Docket Number:	79-AFC-02C
Project Title:	NCPA/Shell Geothermal Project #2 (78-NOI-5) - Compliance
TN #:	206112-2
Document Title:	NCPA Unit 1 (Formerly Unit 2) Plot Plan
Description:	N/A
Filer:	Camile Remy-Obad
Organization:	California Energy Commission
Submitter Role:	Commission Staff
Submission Date:	9/15/2015 3:38:48 PM
Docketed Date:	9/15/2015

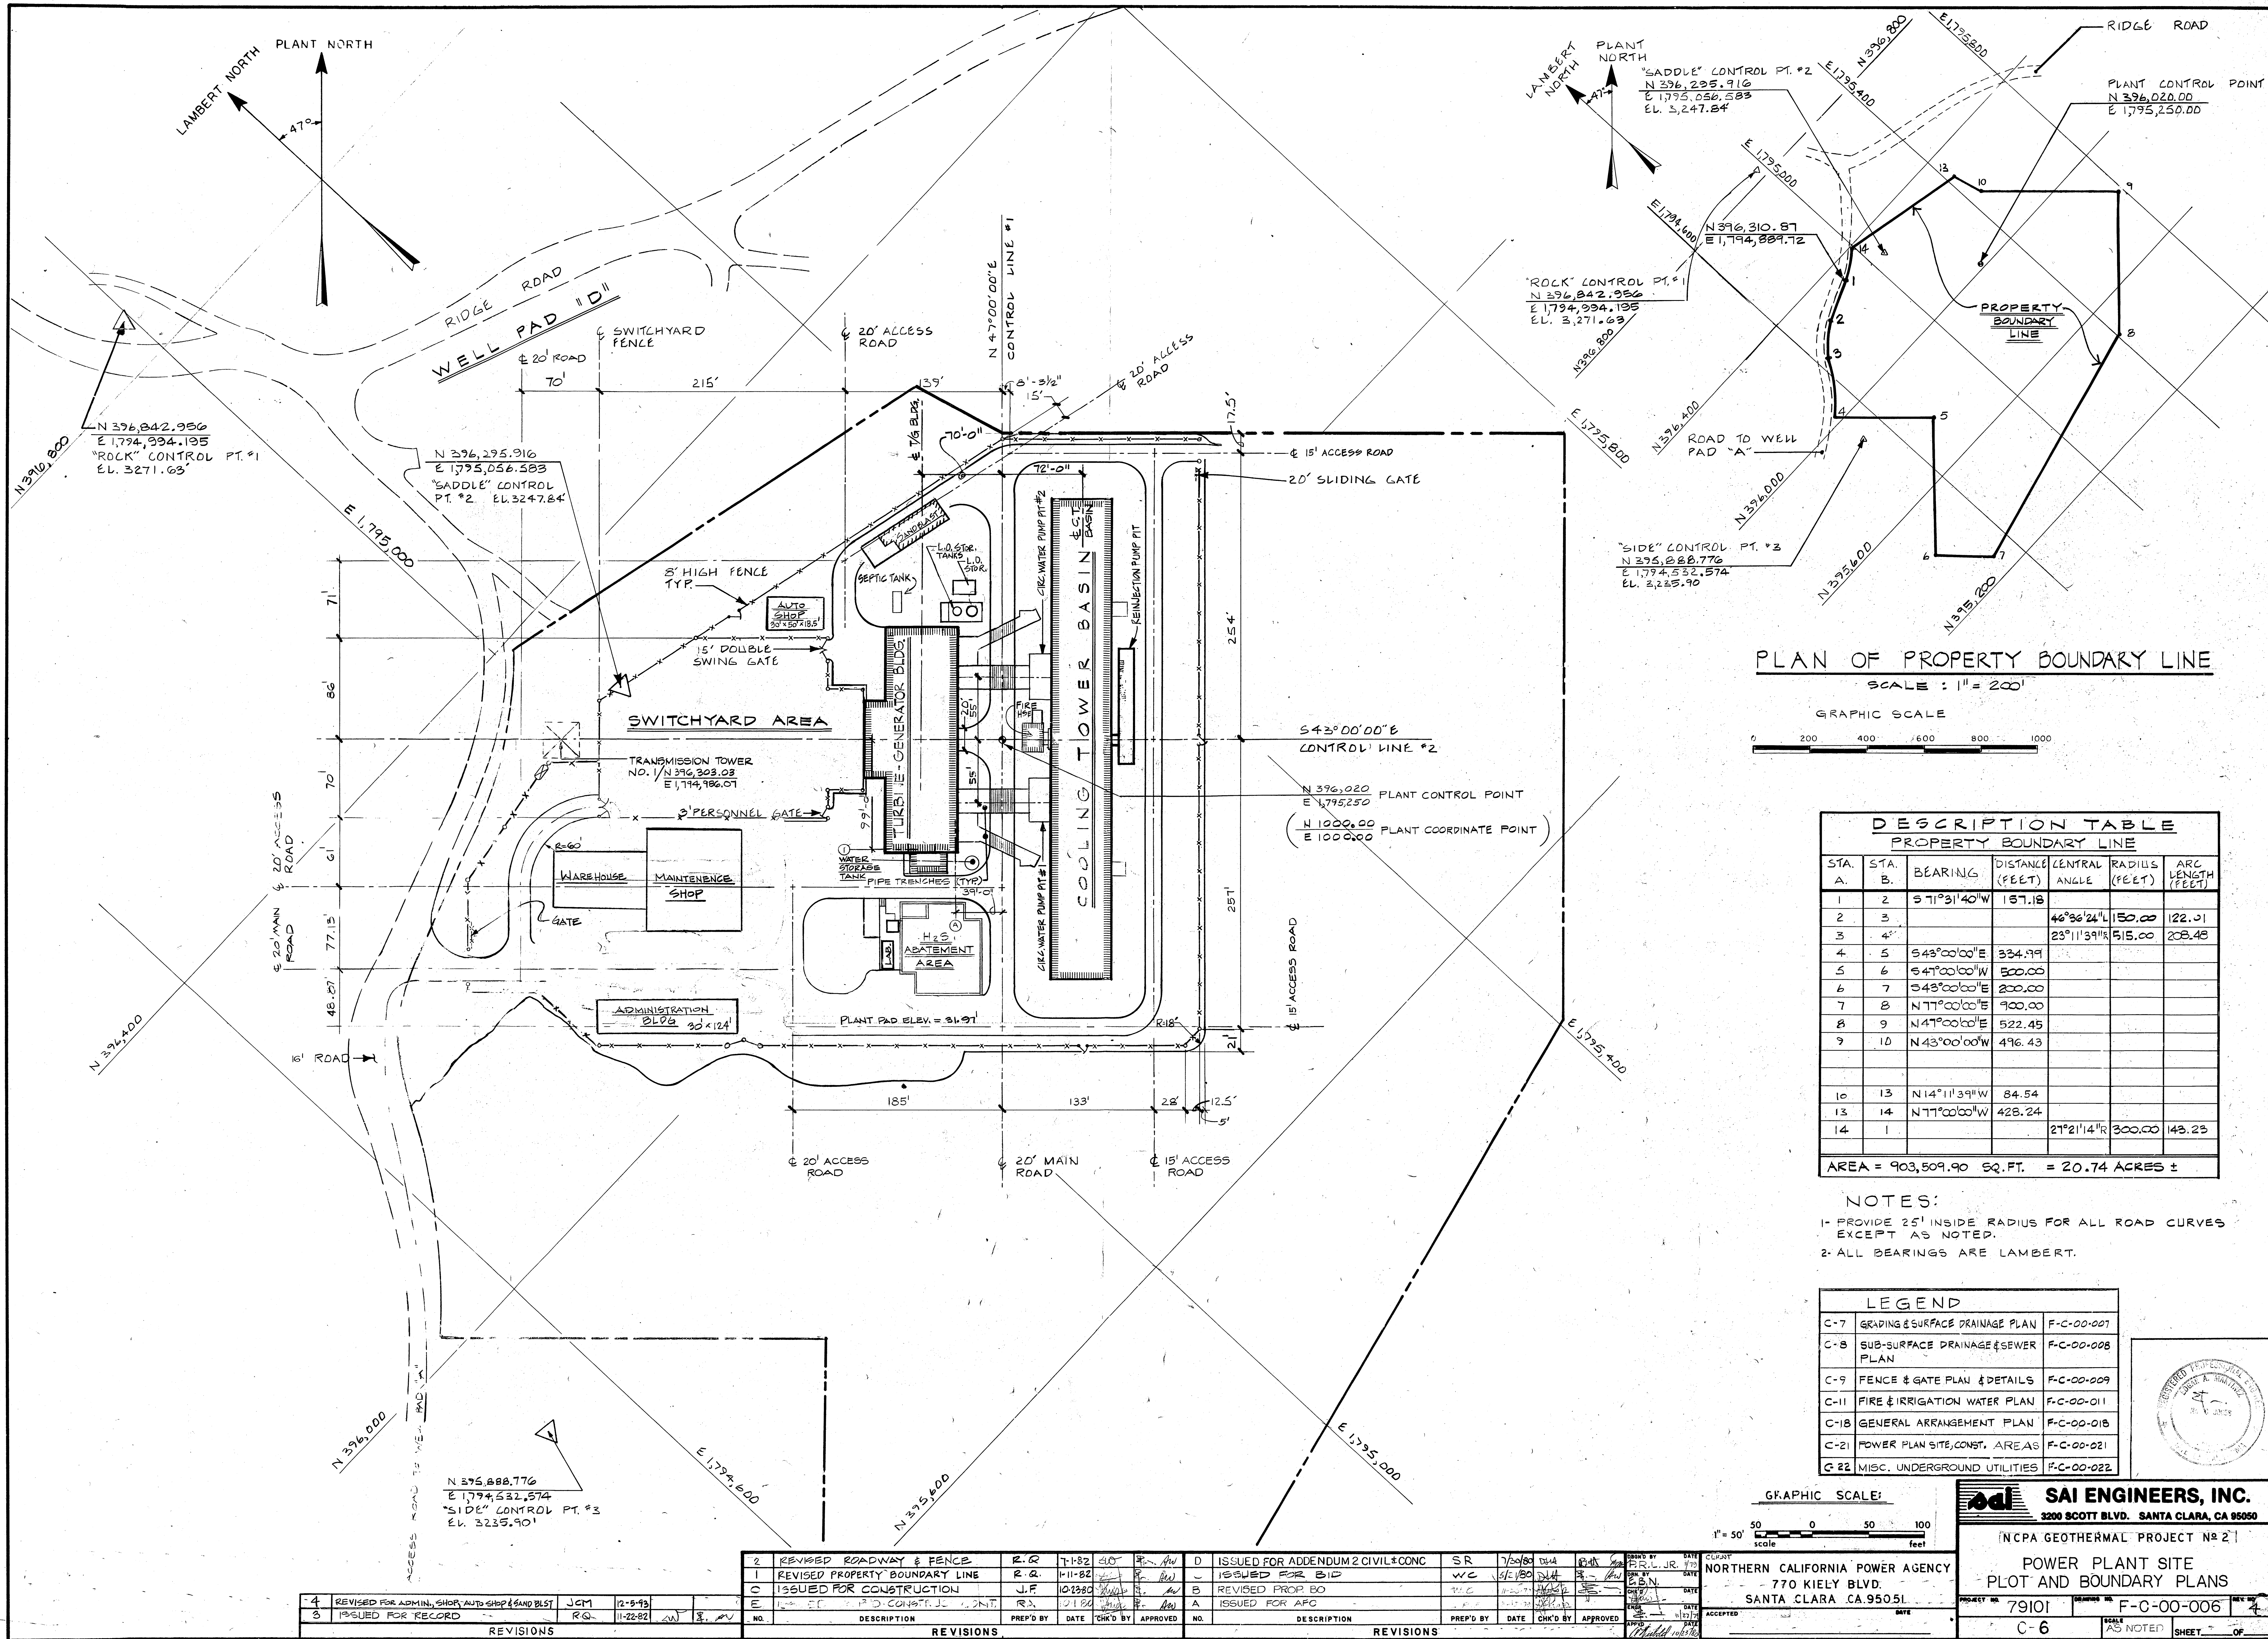

PLAN OF PROPERTY BOUNDARY LINE

SCALE: 1" = 200'

GRAPHIC SCALE



DESCRIPTION TABLE
PROPERTY BOUNDARY LINE

STA. A.	STA. B.	BEARING	DISTANCE (FEET)	CENTRAL ANGLE	RADIUS (FEET)	ARC LENGTH (FEET)
1	2	S 71°31'40"W	157.18			
2	3			46°36'24"L	150.00	122.01
3	4			23°11'39"W	515.00	208.48
4	5	S 43°00'00"E	334.99			
5	6	S 47°00'00"W	500.00			
6	7	S 43°00'00"E	200.00			
7	8	N 77°00'00"E	900.00			
8	9	N 47°00'00"E	522.45			
9	10	N 43°00'00"W	496.43			
10	13	N 14°11'39"W	84.54			
13	14	N 77°00'00"W	428.24			
14	1			27°21'14"R	300.00	143.23

AREA = 903,509.90 SQ. FT. = 20.74 ACRES ±


NOTES:

- 1- PROVIDE 25' INSIDE RADIUS FOR ALL ROAD CURVES EXCEPT AS NOTED.
- 2- ALL BEARINGS ARE LAMBERT.

LEGEND

C-7	GRADING & SURFACE DRAINAGE PLAN	F-C-00-007
C-8	SUB-SURFACE DRAINAGE & SEWER PLAN	F-C-00-008
C-9	FENCE & GATE PLAN & DETAILS	F-C-00-009
C-11	FIRE & IRRIGATION WATER PLAN	F-C-00-011
C-18	GENERAL ARRANGEMENT PLAN	F-C-00-018
C-21	POWER PLAN SITE, CONST. AREAS	F-C-00-021
C-22	MISC. UNDERGROUND UTILITIES	F-C-00-022

 GRAPHIC SCALE:



SAI ENGINEERS, INC.

3200 SCOTT BLVD. SANTA CLARA, CA 95050

NCPA GEOTHERMAL PROJECT No. 2

POWER PLANT SITE
PLOT AND BOUNDARY PLANS

PROJECT NO. 79101 DRAWING NO. F-C-00-006

C-6 AS NOTED SHEET 4 OF 4

NO.	DESCRIPTION	PREP'D BY	DATE	CHK'D BY	APPROVED
4	REVISED FOR ADMIN. SHOP, AUTO SHOP & SAND BLST	JCM	12-5-93		
3	ISSUED FOR RECORD	RQ	11-22-92		

NO.	DESCRIPTION	PREP'D BY	DATE	CHK'D BY	APPROVED
2	REVISED ROADWAY & FENCE	R.G.	7-1-82		
1	REVISED PROPERTY BOUNDARY LINE	R.G.	11-11-82		
C	ISSUED FOR CONSTRUCTION	J.F.	10-23-80		
E	1-2-82	R.D.	01-18-82		

NO.	DESCRIPTION	PREP'D BY	DATE	CHK'D BY	APPROVED
D	ISSUED FOR ADDENDUM 2 CIVIL & CONC	SR	7/20/89		
WC	ISSUED FOR BID	WC	5/15/80		
B	REVISED PROP. BO				
A	ISSUED FOR AFO				