


GWF Hanford Property Line setbacks

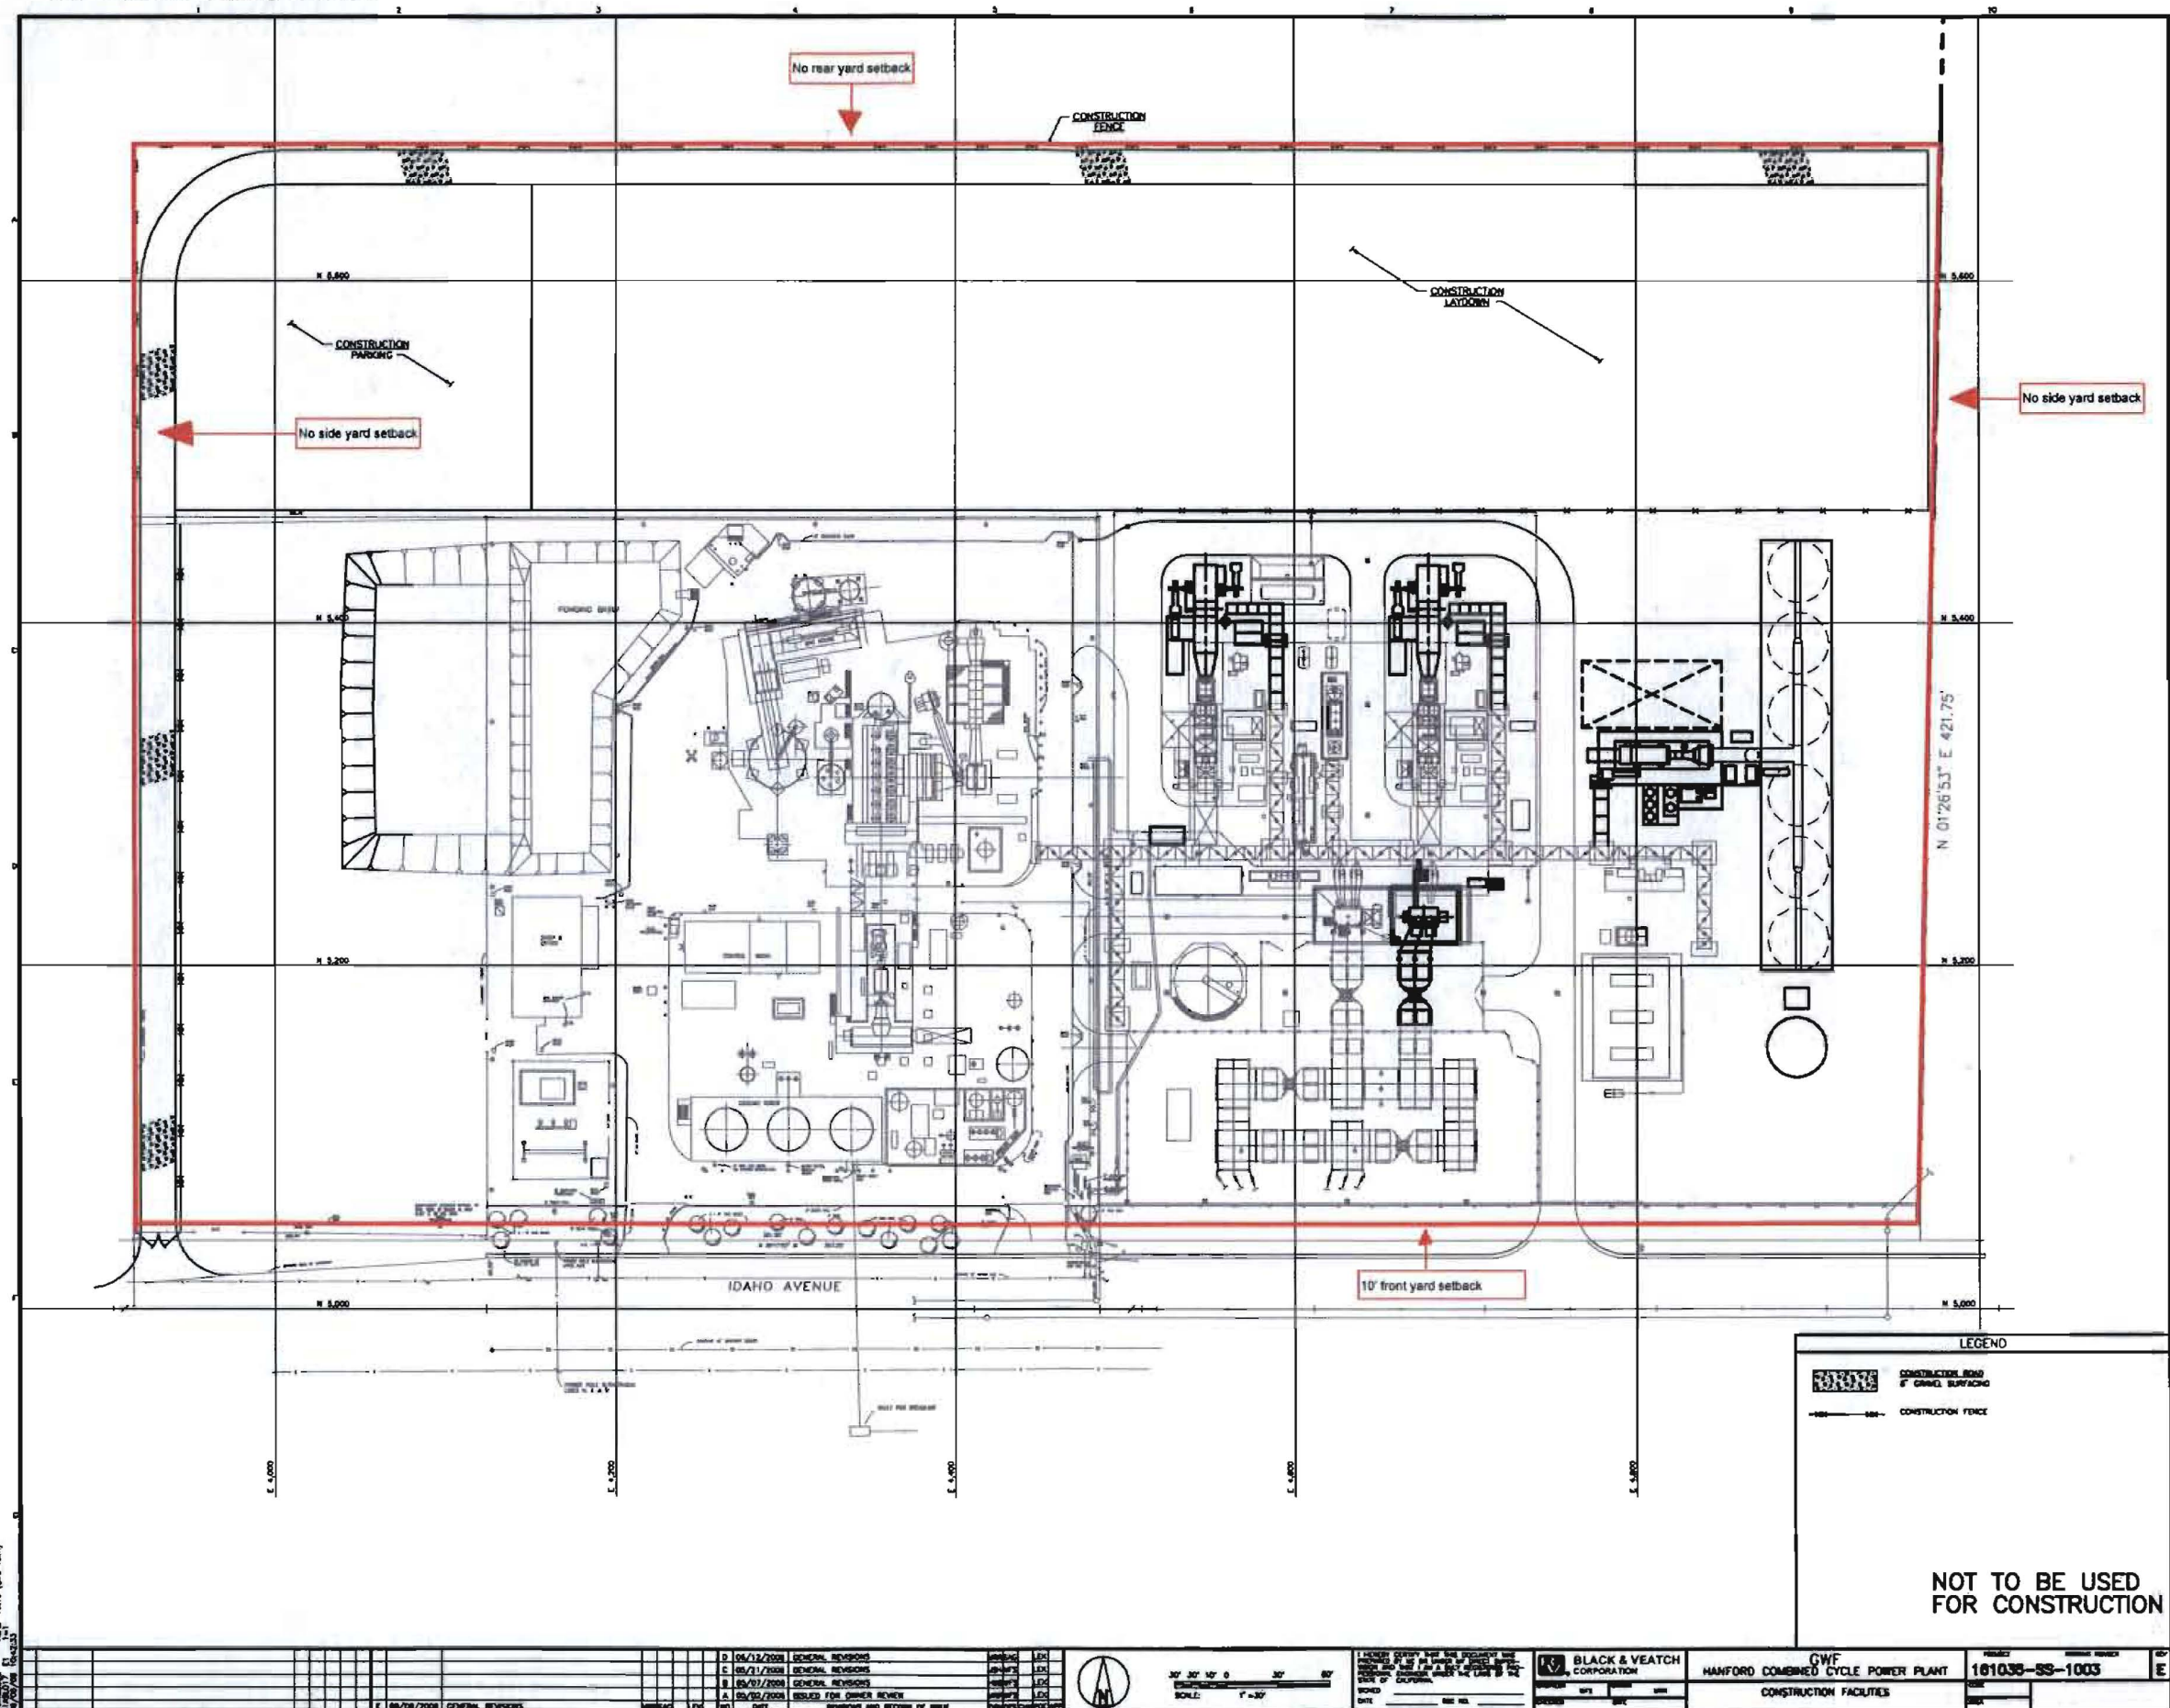

NOT TO BE USED
FOR CONSTRUCTION

PROJECT: GWF Hanford
DATE: 06/11/2008
DRAWN BY: [Name]
CHECKED BY: [Name]
APPROVED BY: [Name]

NO.	DATE	DESCRIPTION	BY	CHK
1	06/11/2008	GENERAL REVISIONS	[Name]	[Name]
2	06/11/2008	GENERAL REVISIONS	[Name]	[Name]
3	06/11/2008	GENERAL REVISIONS	[Name]	[Name]
4	06/11/2008	GENERAL REVISIONS	[Name]	[Name]
5	06/11/2008	GENERAL REVISIONS	[Name]	[Name]
6	06/11/2008	GENERAL REVISIONS	[Name]	[Name]
7	06/11/2008	GENERAL REVISIONS	[Name]	[Name]
8	06/11/2008	GENERAL REVISIONS	[Name]	[Name]
9	06/11/2008	GENERAL REVISIONS	[Name]	[Name]
10	06/11/2008	GENERAL REVISIONS	[Name]	[Name]



30' 20' 10' 0'
1" = 30'

BLACK & VEATCH
CORPORATION

GWF
HANFORD COMBINED CYCLE POWER PLANT
CONSTRUCTION FACILITIES

PROJECT: 161035-SS-1003
DATE: 06/11/2008
DRAWN BY: [Name]
CHECKED BY: [Name]
APPROVED BY: [Name]

LEGEND
CONSTRUCTION ROAD
CONSTRUCTION SURFACE
CONSTRUCTION FENCE

NOT TO BE USED
FOR CONSTRUCTION

161035-SS-1003