

DOCKETED	
Docket Number:	01-AFC-17C
Project Title:	Inland Empire Energy Center Project Compliance
TN #:	231971
Document Title:	Stormwater Pollution Prevention Plan, Appendices Volume 1
Description:	N/A
Filer:	Paul Kihm
Organization:	Latham & Watkins LLP
Submitter Role:	Applicant Representative
Submission Date:	2/6/2020 5:09:43 PM
Docketed Date:	2/7/2020

STORMWATER POLLUTION PREVENTION PLAN

APPENDICES VOLUME 1

Inland Empire Energy Center
Decommissioning and Demolition

RISK LEVEL 1

Legally Responsible Person [LRP]:

Frank Escobedo
Inland Empire Energy Center, LLC
26226 Antelope Road, Menifee, CA 92585
951-928-5941

Approved Signatory:

Not Applicable

Prepared for:

Inland Empire Energy Center, LLC
26226 Antelope Road, Menifee, CA 92585

Project Address:

26226 Antelope Road
Menifee, CA 92585

SWPPP Prepared by:

ATC Group Services
25 Cupania Circle
Monterey Park, CA 91755
Jay Schneider

SWPPP Preparation Date

01/09/2020

Estimated Project Dates:

Start of Construction	February 10, 2020	Completion of Construction	December 31, 2020
-----------------------	------------------------------	----------------------------	--------------------------

Appendix A: Calculations

INLAND EMPIRE ENERGY CENTER
PROJECT W.O. 00-340

PROCESS AREA RETENTION BASIN
DEPTHS AND STORAGE


No.	WATER SURF. ELEV. - Ft.	BASIN DEPTH - Ft.	BASIN VOLUME Ac.Ft.
1	1439.50	0.00	0
2	1439.75	0.30	0.016
3	1440.00	0.50	0.125
4	1440.25	0.75	0.398
5	1440.50	1.00	0.876
6	1440.75	1.25	1.576
7	1441.00	1.50	2.392
8	1441.25	1.75	3.226
9	1441.50	2.00	4.070
10	1441.75	2.25	4.927
11	1442.00	2.50	5.794
12	1442.25	2.75	6.674
13	1442.50	3.00	7.564
14	1442.75	3.25	8.466
15	1443.00	3.50	9.380

PROCESS AREA - BASIN DISCHARGE

<u>24-HOUR STORM</u>	Unit Hydrograph Results			
	Pre-developed		Post-developed	
	<u>Flood Volume</u>	<u>Peak Flow</u>	<u>Flood Volume</u>	<u>Peak Flow</u>
	Ac.Ft.	CFS	Ac.Ft.	CFS
2-YEAR	0.40	0.63	2.40	4.60
5-YEAR	0.50	1.60	3.60	7.04
10-YEAR	2.20	6.80	4.80	9.08
25-YEAR	3.20	9.00	6.00	12.30
100-YEAR	4.70	12.30	8.00	16.03

6" outlet pipe at bottom basin elevation 1439.5

ORIGINAL

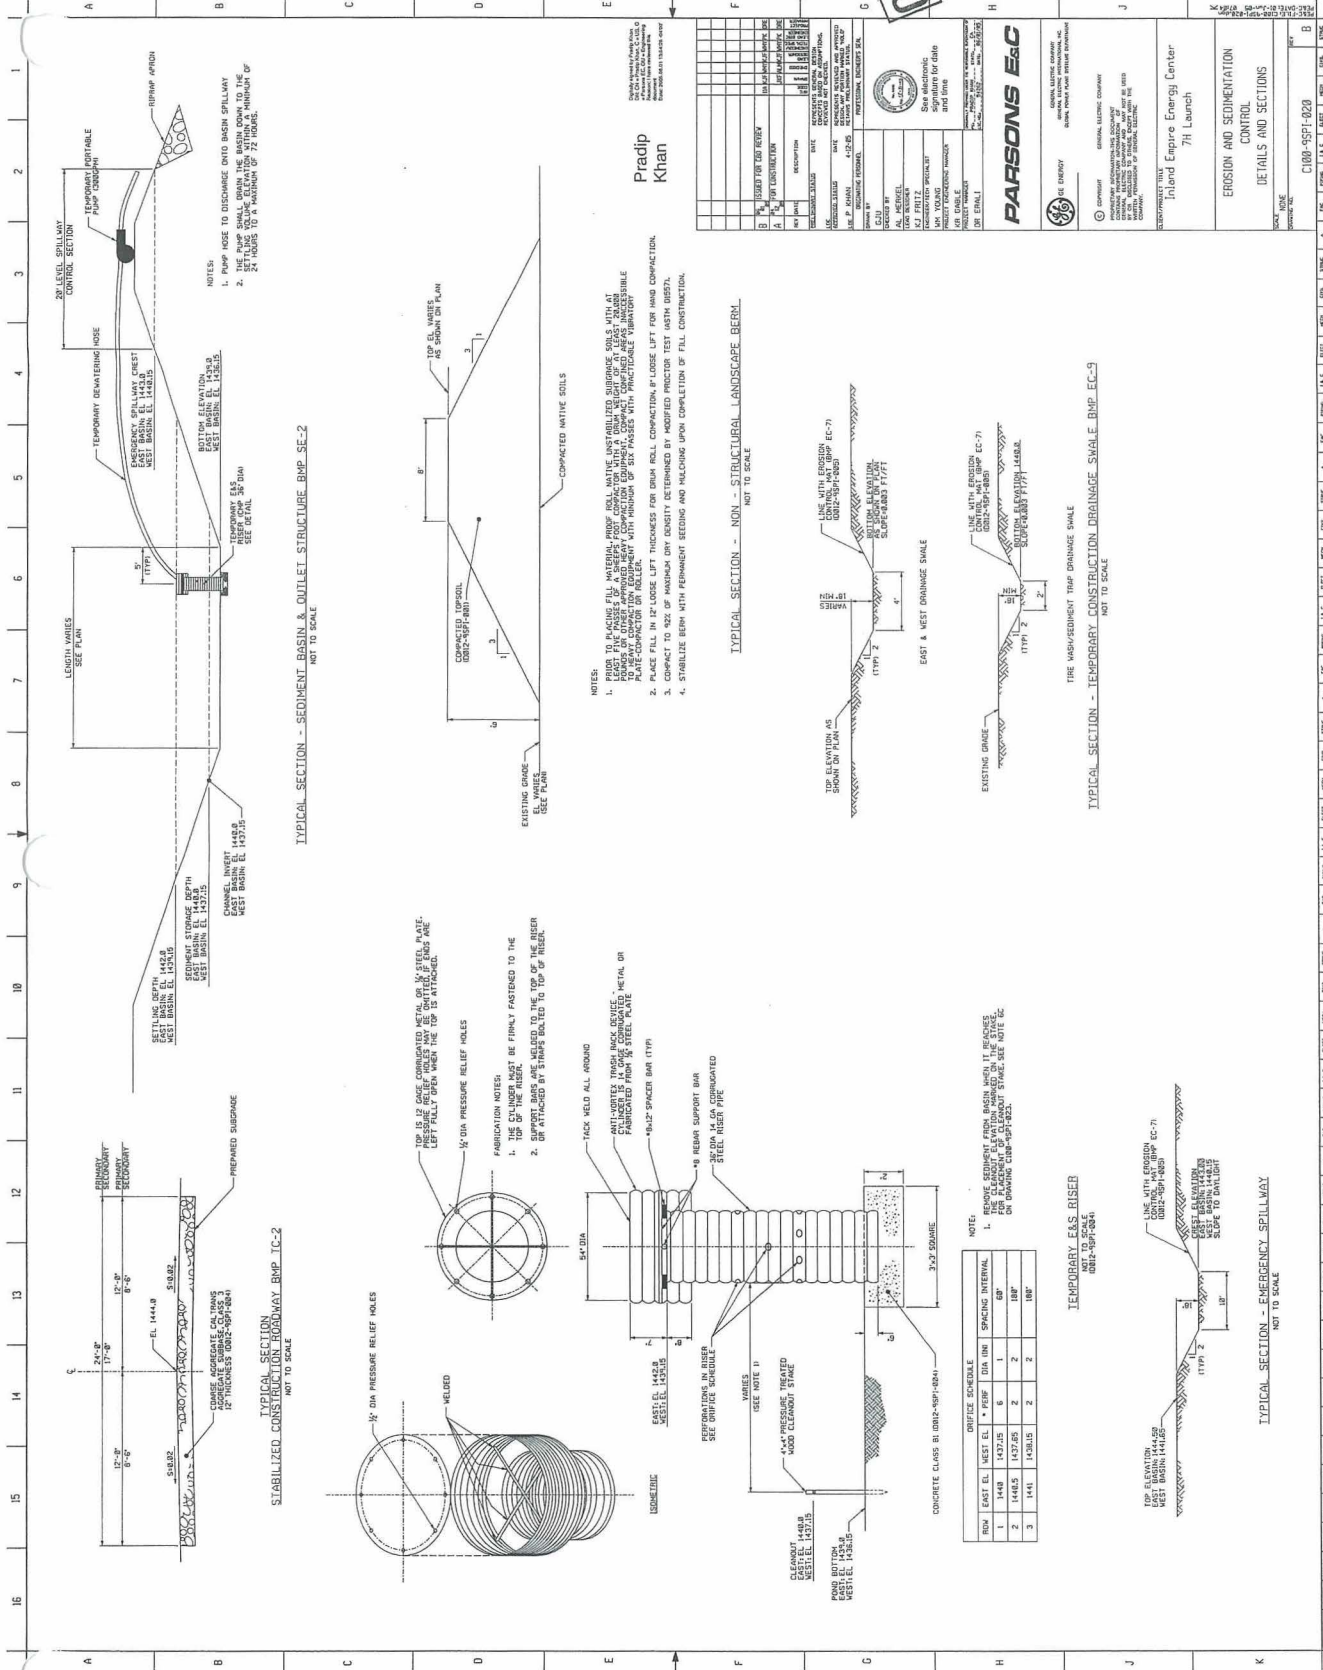

Pradip Khan

NO.	REVISION	DATE	BY	CHKD	APP'D
1	ISSUED FOR BIDDING	08/14/2014	PK		
2	FOR CONSTRUCTION	08/14/2014	PK		
3	FOR CONSTRUCTION	08/14/2014	PK		
4	FOR CONSTRUCTION	08/14/2014	PK		
5	FOR CONSTRUCTION	08/14/2014	PK		
6	FOR CONSTRUCTION	08/14/2014	PK		
7	FOR CONSTRUCTION	08/14/2014	PK		
8	FOR CONSTRUCTION	08/14/2014	PK		
9	FOR CONSTRUCTION	08/14/2014	PK		
10	FOR CONSTRUCTION	08/14/2014	PK		
11	FOR CONSTRUCTION	08/14/2014	PK		
12	FOR CONSTRUCTION	08/14/2014	PK		
13	FOR CONSTRUCTION	08/14/2014	PK		
14	FOR CONSTRUCTION	08/14/2014	PK		
15	FOR CONSTRUCTION	08/14/2014	PK		
16	FOR CONSTRUCTION	08/14/2014	PK		

PARSONS E&C

NEW YORK, NY 10017-2400
TEL: 212 512 2000
FAX: 212 512 2001
WWW.PARSONSEANDC.COM


GENERAL ELECTRIC COMPANY

INLAND EMPIRE ENERGY CENTER
7th Launch

EROSION AND SEDIMENTATION CONTROL DETAILS AND SECTIONS

DATE: 08/14/2014
DRAWN: PK
CHECKED: PK
APPROVED: PK

C:\WORK\9591-020

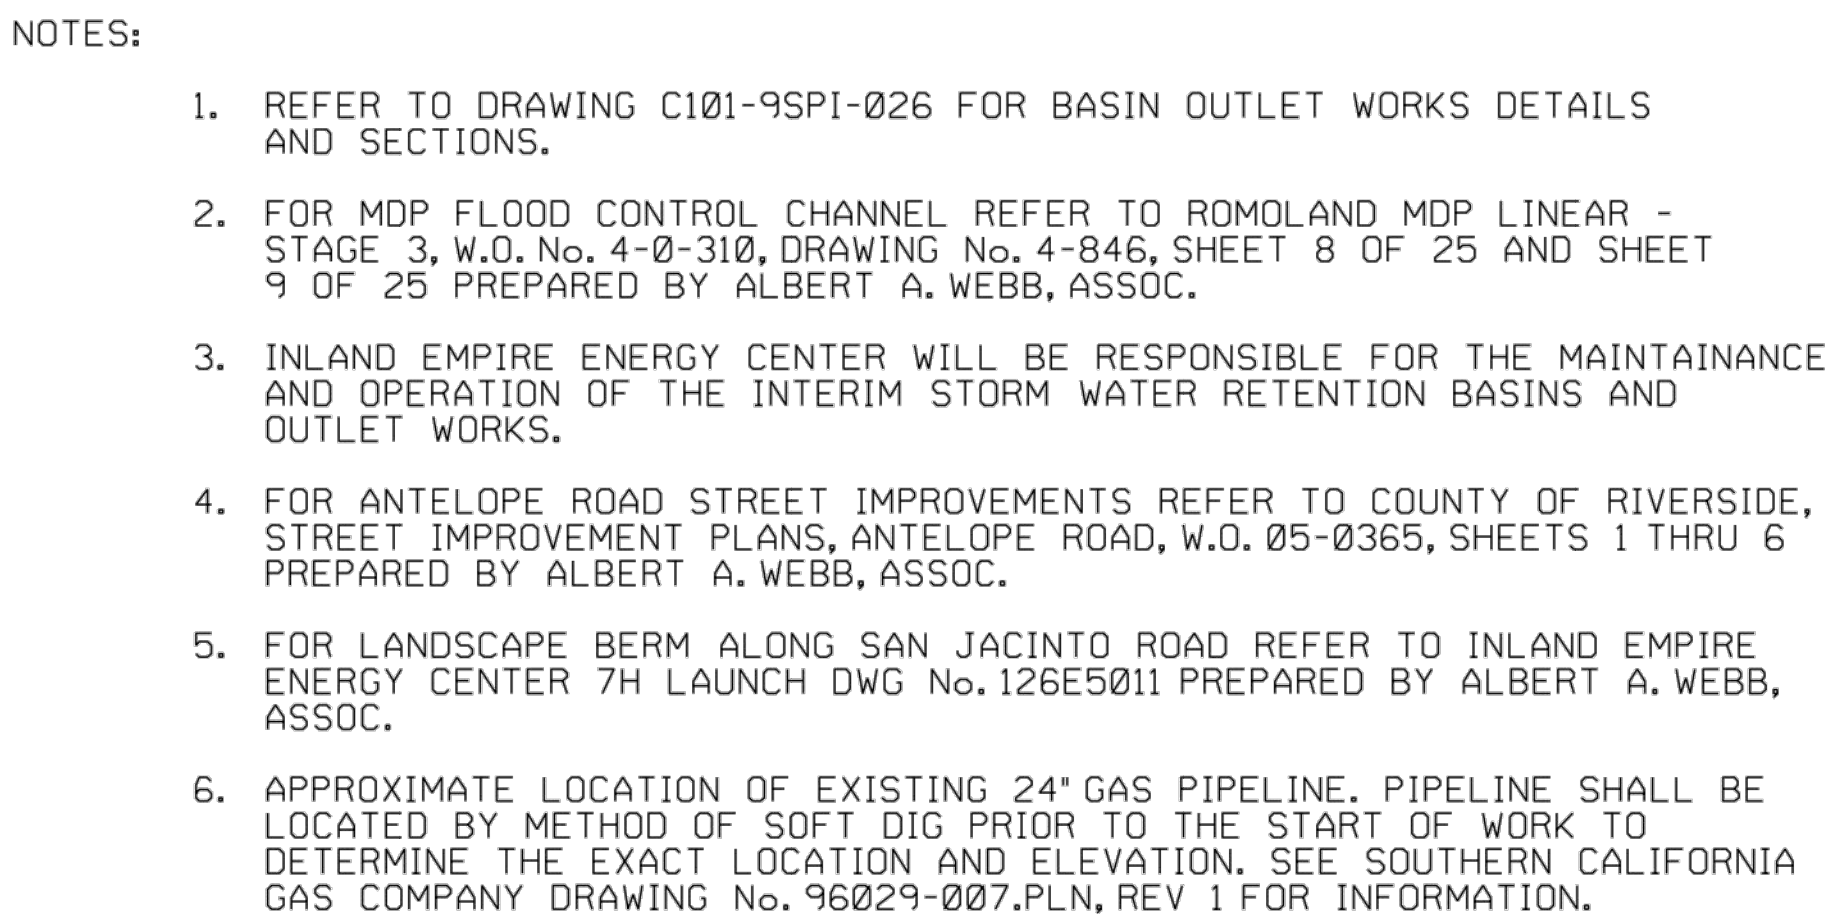



Robert L.
Dunn, P.E.

REFERENCES:

C101-9SPI-026 INTERIM STORM WATER RETENTION
BASINS OUTLET WORKS
DETAILS AND SECTIONS

Pradip Khan

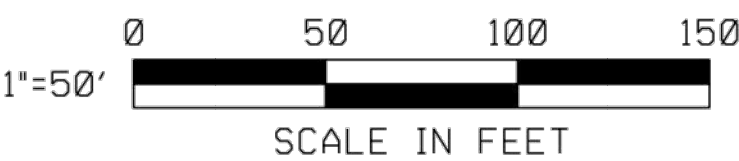

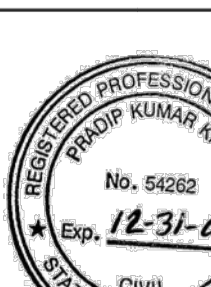A	08/09/08	FOR CONSTRUCTION	01	MS	KJF	KJF	DM	PK	DRE
	02/08/08	FOR CBO APPROVAL AND BID							
				MS	RES	KJF	WM	PK	DRE
REV	DATE	DESCRIPTION	ISS	REV	BY	CHKD	APPD	DATE	PROJECT
<u>PRELIMINARY STATUS</u>			DATE	REPRESENTS GENERAL DESIGN CONCEPTS BASED ON ASSUMPTIONS. REVIEWED NOT CHECKED.					
<u>APPROVED STATUS</u>			DATE	REPRESENTS REVIEWED AND APPROVED DESIGN. ANY PORTION MARKED "HOLD" RETAINS PRELIMINARY STATUS.					
P L K HAN			02/28/08	PROFESSIONAL ENGINEER'S SEAL  See Electronic Signature for Date & Time					
ORIGINATING PERSONNEL									
DRAWN BY									
MS									
CHECKED BY									
RE STOUDT									
LEAD DESIGNER									
K J FRITZ									
ENGINEER/TECH SPECIALIST									
WM YOUNG									
PROJECT ENGINEERING MANAGER									
DM WITZEL									
PROJECT MANAGER									
DR ERALI									

PARSONS E&C



© COPYRIGHT 2005 GENERAL ELECTRIC COMPANY

PROPRIETARY INFORMATION-THIS DOCUMENT
CONTAINS PROPRIETARY INFORMATION OF
GENERAL ELECTRIC COMPANY AND MAY NOT BE USED
BY OR DISCLOSED TO OTHERS, EXCEPT WITH THE
WRITTEN PERMISSION OF GENERAL ELECTRIC
COMPANY.

 ENVIRONMENTAL • GEOTECHNICAL BUILDING SOLUTIONS • MATERIALS TESTING 25 CUPANINA CIRCLE MONTGOMERY PARK, CA 91755 Ph: (323) 517-0780 atcgroupservices.com SHEET CONTENTS:	PROJECT NUMBER NPGEEN19001	
	PHASE 2	DATE 12-5-19
	REVIEWED BY: J. NUCCIO	
	CHECKED BY: J. SCHNEIDER	DRAWN BY: DAW
	IEEC STORMWATER RETENTION BASINS PLAN	

SCALE 1"=50'		
DRAWING NO. C101-9SPI-006	REV A	

DEMOLITION NOTES:

- 1. FINAL GRADE ON SITE DRAINAGE TO BE COMPLETED BY DEMOLITION CONTRACTORS IN ACCORDANCE WITH SURFACE ELEVATIONS ON DRAINAGE STRUCTURES NOTED ON THIS DRAWING.**

LEGEND:

- 1 STORMWATER SAMPLING LOCATIONS.

NOTE: PROVIDED FOR REFERENCE ONLY.

... \c101-9api-006.dgn
06.09.2008 7:38:02 AM

National Stormwater Calculator Report

Site Description

IEEC

Parameter	Current Scenario	Baseline Scenario
Site Area (acres)	45.8	
Hydrologic Soil Group	C	
Hydraulic Conductivity (in/hr)	1.0	
Surface Slope (%)	2	
Precip. Data Source	SUN CITY	
Evap. Data Source	SUN CITY	
Climate Change Scenario	None	
% Forest	10	
% Meadow	26	
% Lawn	0	
% Desert	39	
% Impervious	25	
Years Analyzed	20	
Ignore Consecutive Wet Days	False	
Wet Day Threshold (inches)	0.10	

LID Control	Current Scenario	Baseline Scenario
Disconnection	0	
Rain Harvesting	0	
Rain Gardens	0	
Green Roofs	0	
Street Planters	0	
Infiltration Basins	100 / 5	
Porous Pavement	0	


% of impervious area treated / % of treated area used for LID

National Stormwater Calculator Report

Summary Results



IEEC

Statistic	Current Scenario	Baseline Scenario
Average Annual Rainfall (inches)	11.13	
Average Annual Runoff (inches)	0.70	
Days per Year With Rainfall	18.89	
Days per Year with Runoff	2.55	
Percent of Wet Days Retained	86.51	
Smallest Rainfall w/ Runoff (inches)	0.71	
Largest Rainfall w/o Runoff (inches)	1.51	
Max. Rainfall Retained (inches)	3.26	

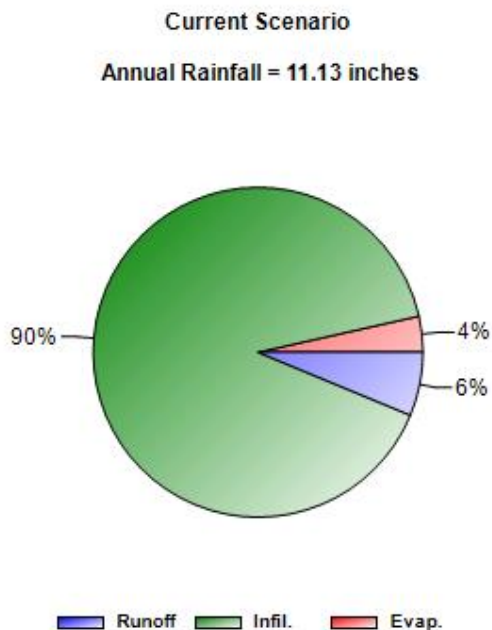



National Stormwater Calculator Report

IEEC

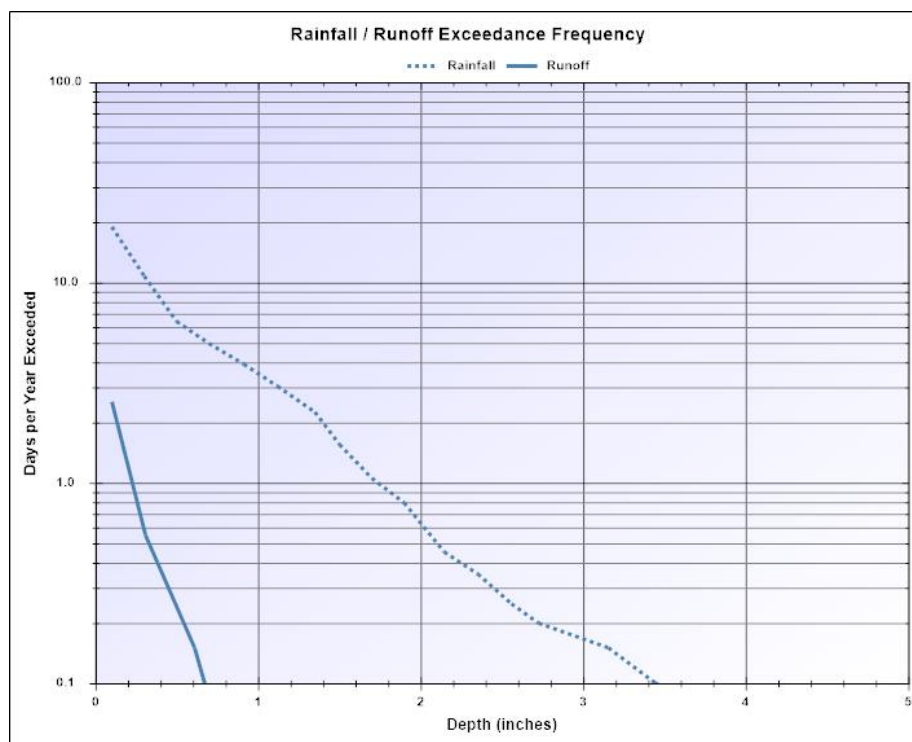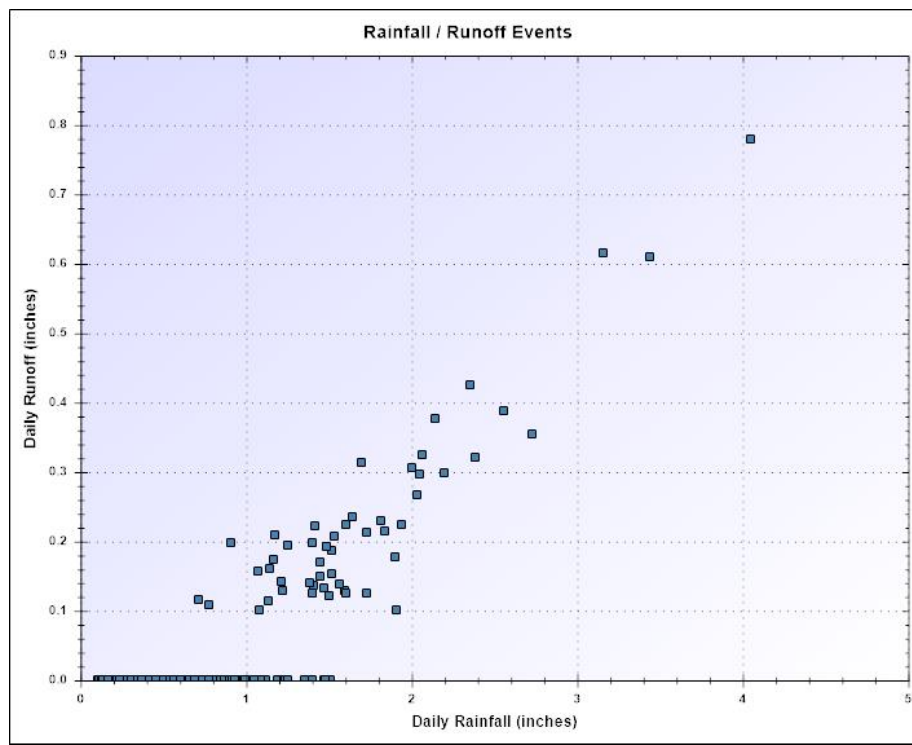



National Stormwater Calculator Report

IEEC

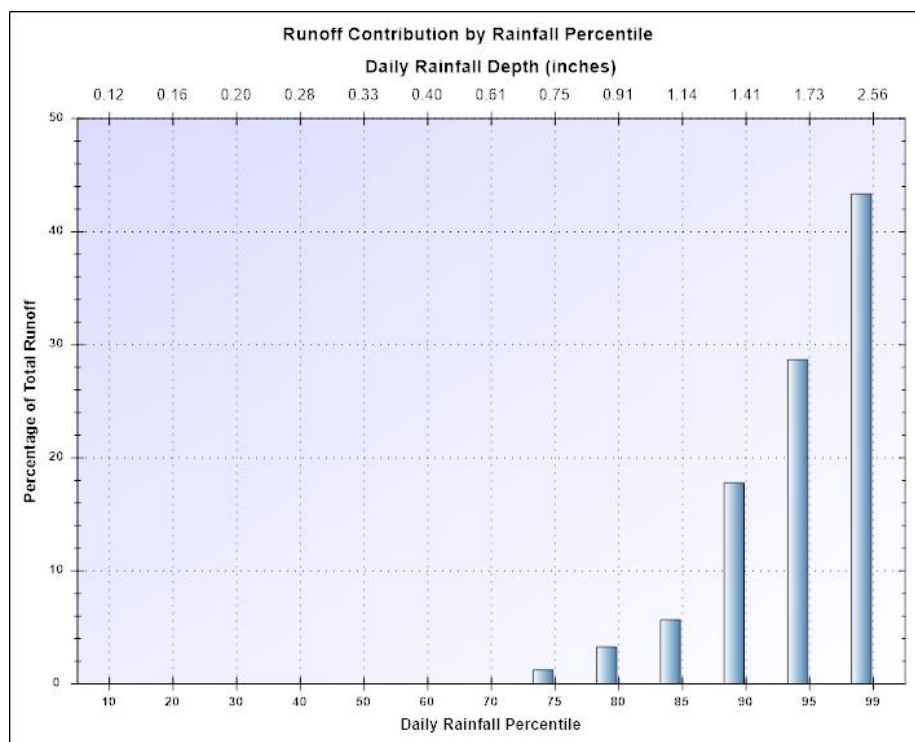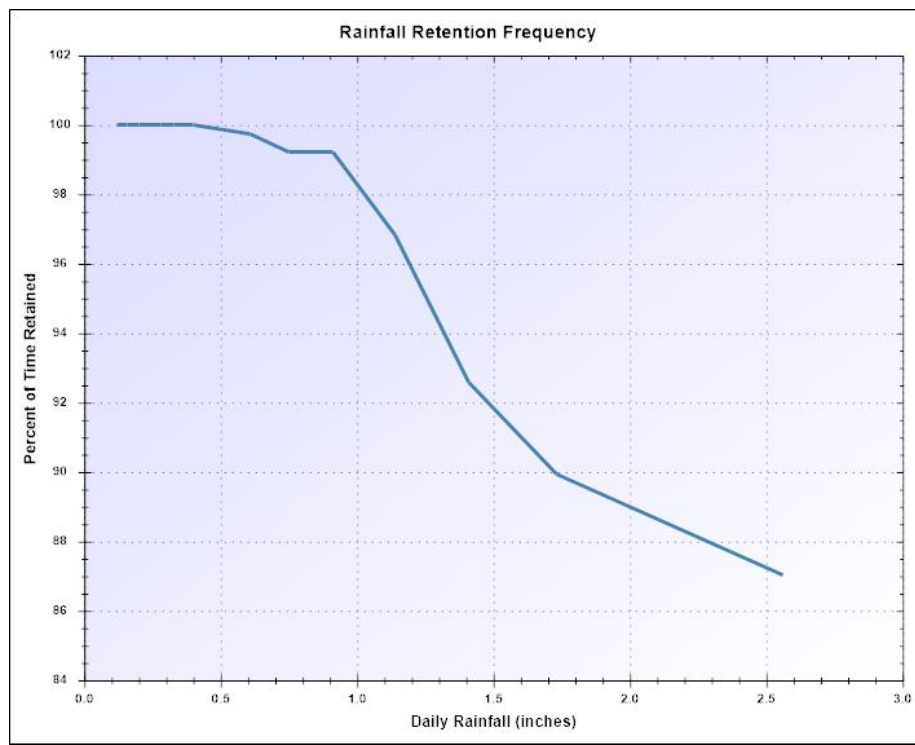

National Stormwater Calculator Report

IEEC

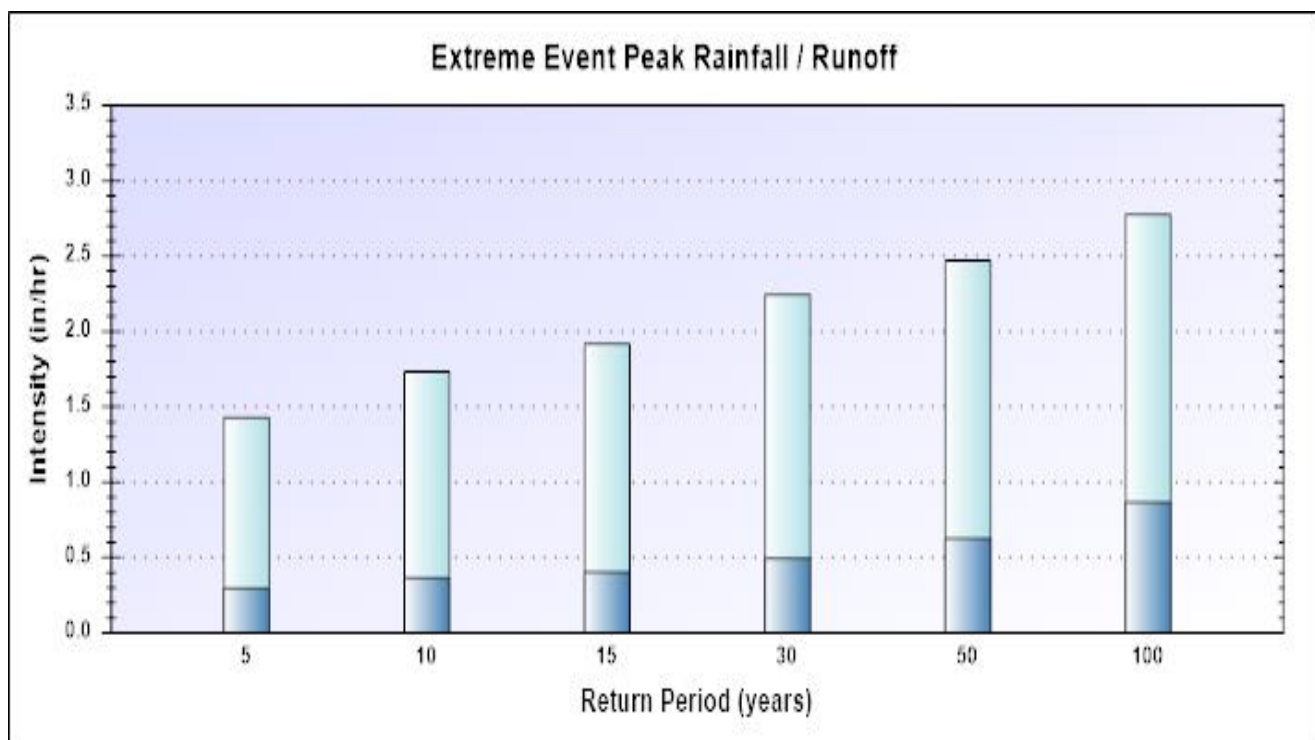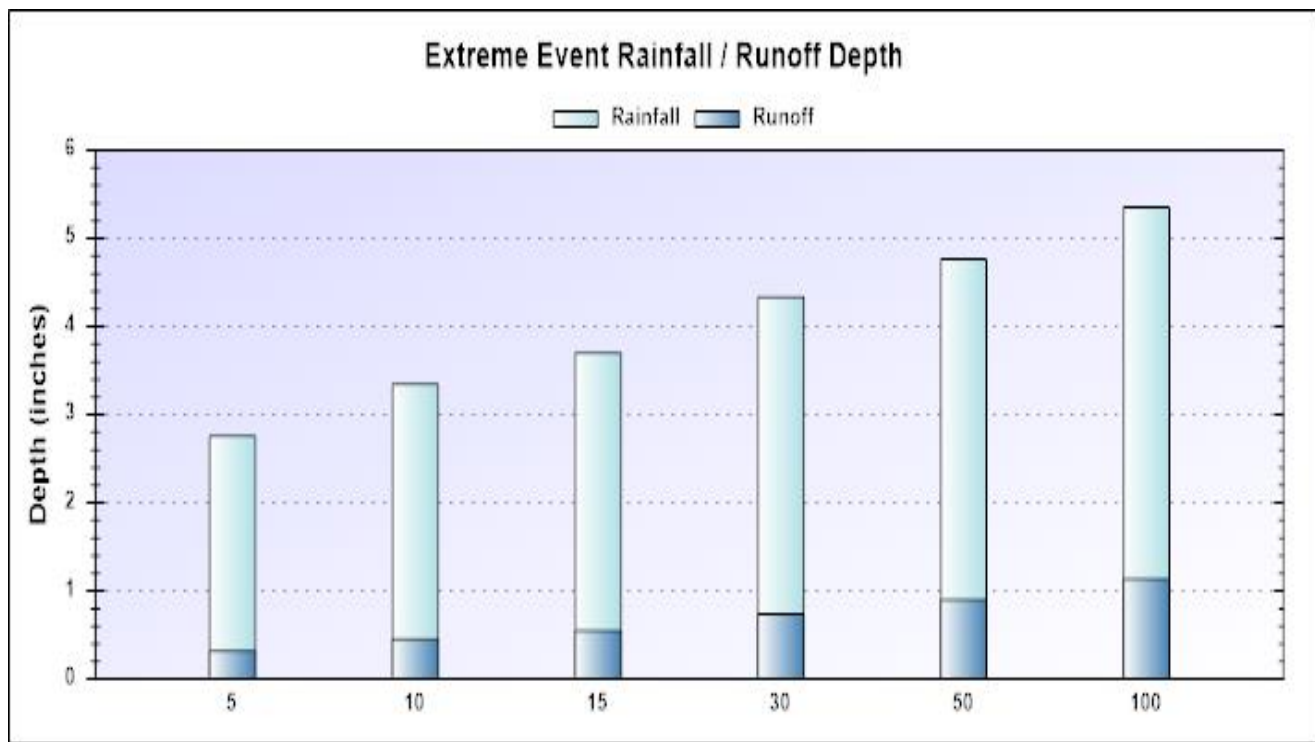

National Stormwater Calculator Report

Estimate of Probable Costs

IEEC


Capital Costs

LID Control	Current Scenario	Baseline Scenario	Cost Difference
Disconnection	\$ - \$		
Rainwater Harvesting	\$ - \$		
Rain Gardens	\$ - \$		
Green Roofs	\$ - \$		
Street Planters	\$ - \$		
Infiltration Basins	\$ 489,200 - \$ 677,900		
Permeable Pavement	\$ - \$		
Total	\$ 489,200 - \$ 677,900		

Maintenance Costs


LID Control	Current Scenario	Baseline Scenario	Cost Difference
Disconnection	\$ - \$		
Rainwater Harvesting	\$ - \$		
Rain Gardens	\$ - \$		
Green Roofs	\$ - \$		
Street Planters	\$ - \$		
Infiltration Basins	\$ 6,100 - \$ 222,800		
Permeable Pavement	\$ - \$		
Total	\$ 6,100 - \$ 222,800		

Appendix B: Site Maps

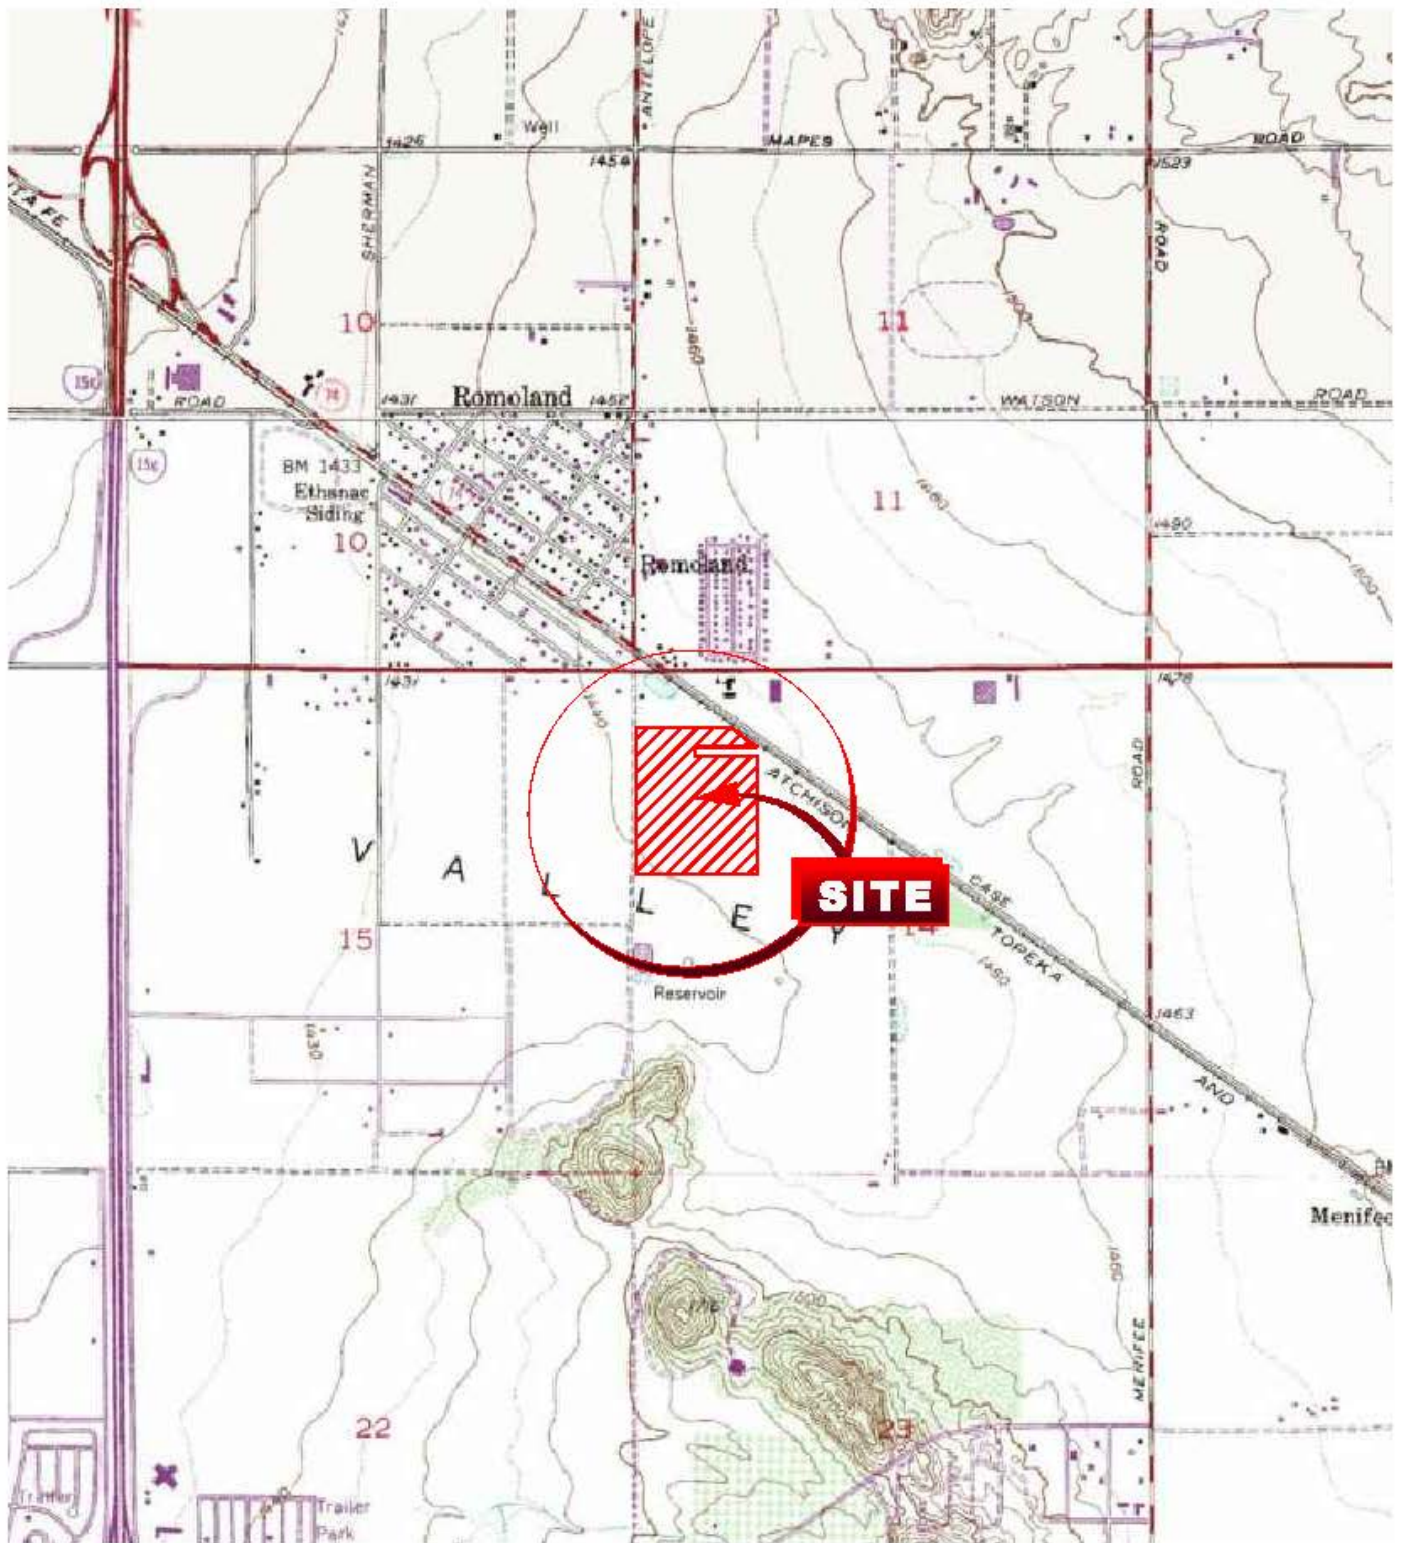

ROMOLAND, CALIFORNIA QUADRANGLE (PROVISIONAL EDITION 1979)

 1:24000 Scale



SITE VICINITY MAP

IEEC SWPPP
INLAND EMPIRE ENERGY CENTER, LLC
 26228 ANTELOPE ROAD
 MENIFEE, CALIFORNIA 92585

PROJECT NUMBER: NPGE18001

PHASE: 2

FIGURE

REVIEW BY: J. SCHNEIDER


DRAWN BY: DAW

1

ATC

25 Cupania Circle
 Monterey Park, CA 91755

Ph: (323) 517-9780 *** Fax: (323) 517-9781

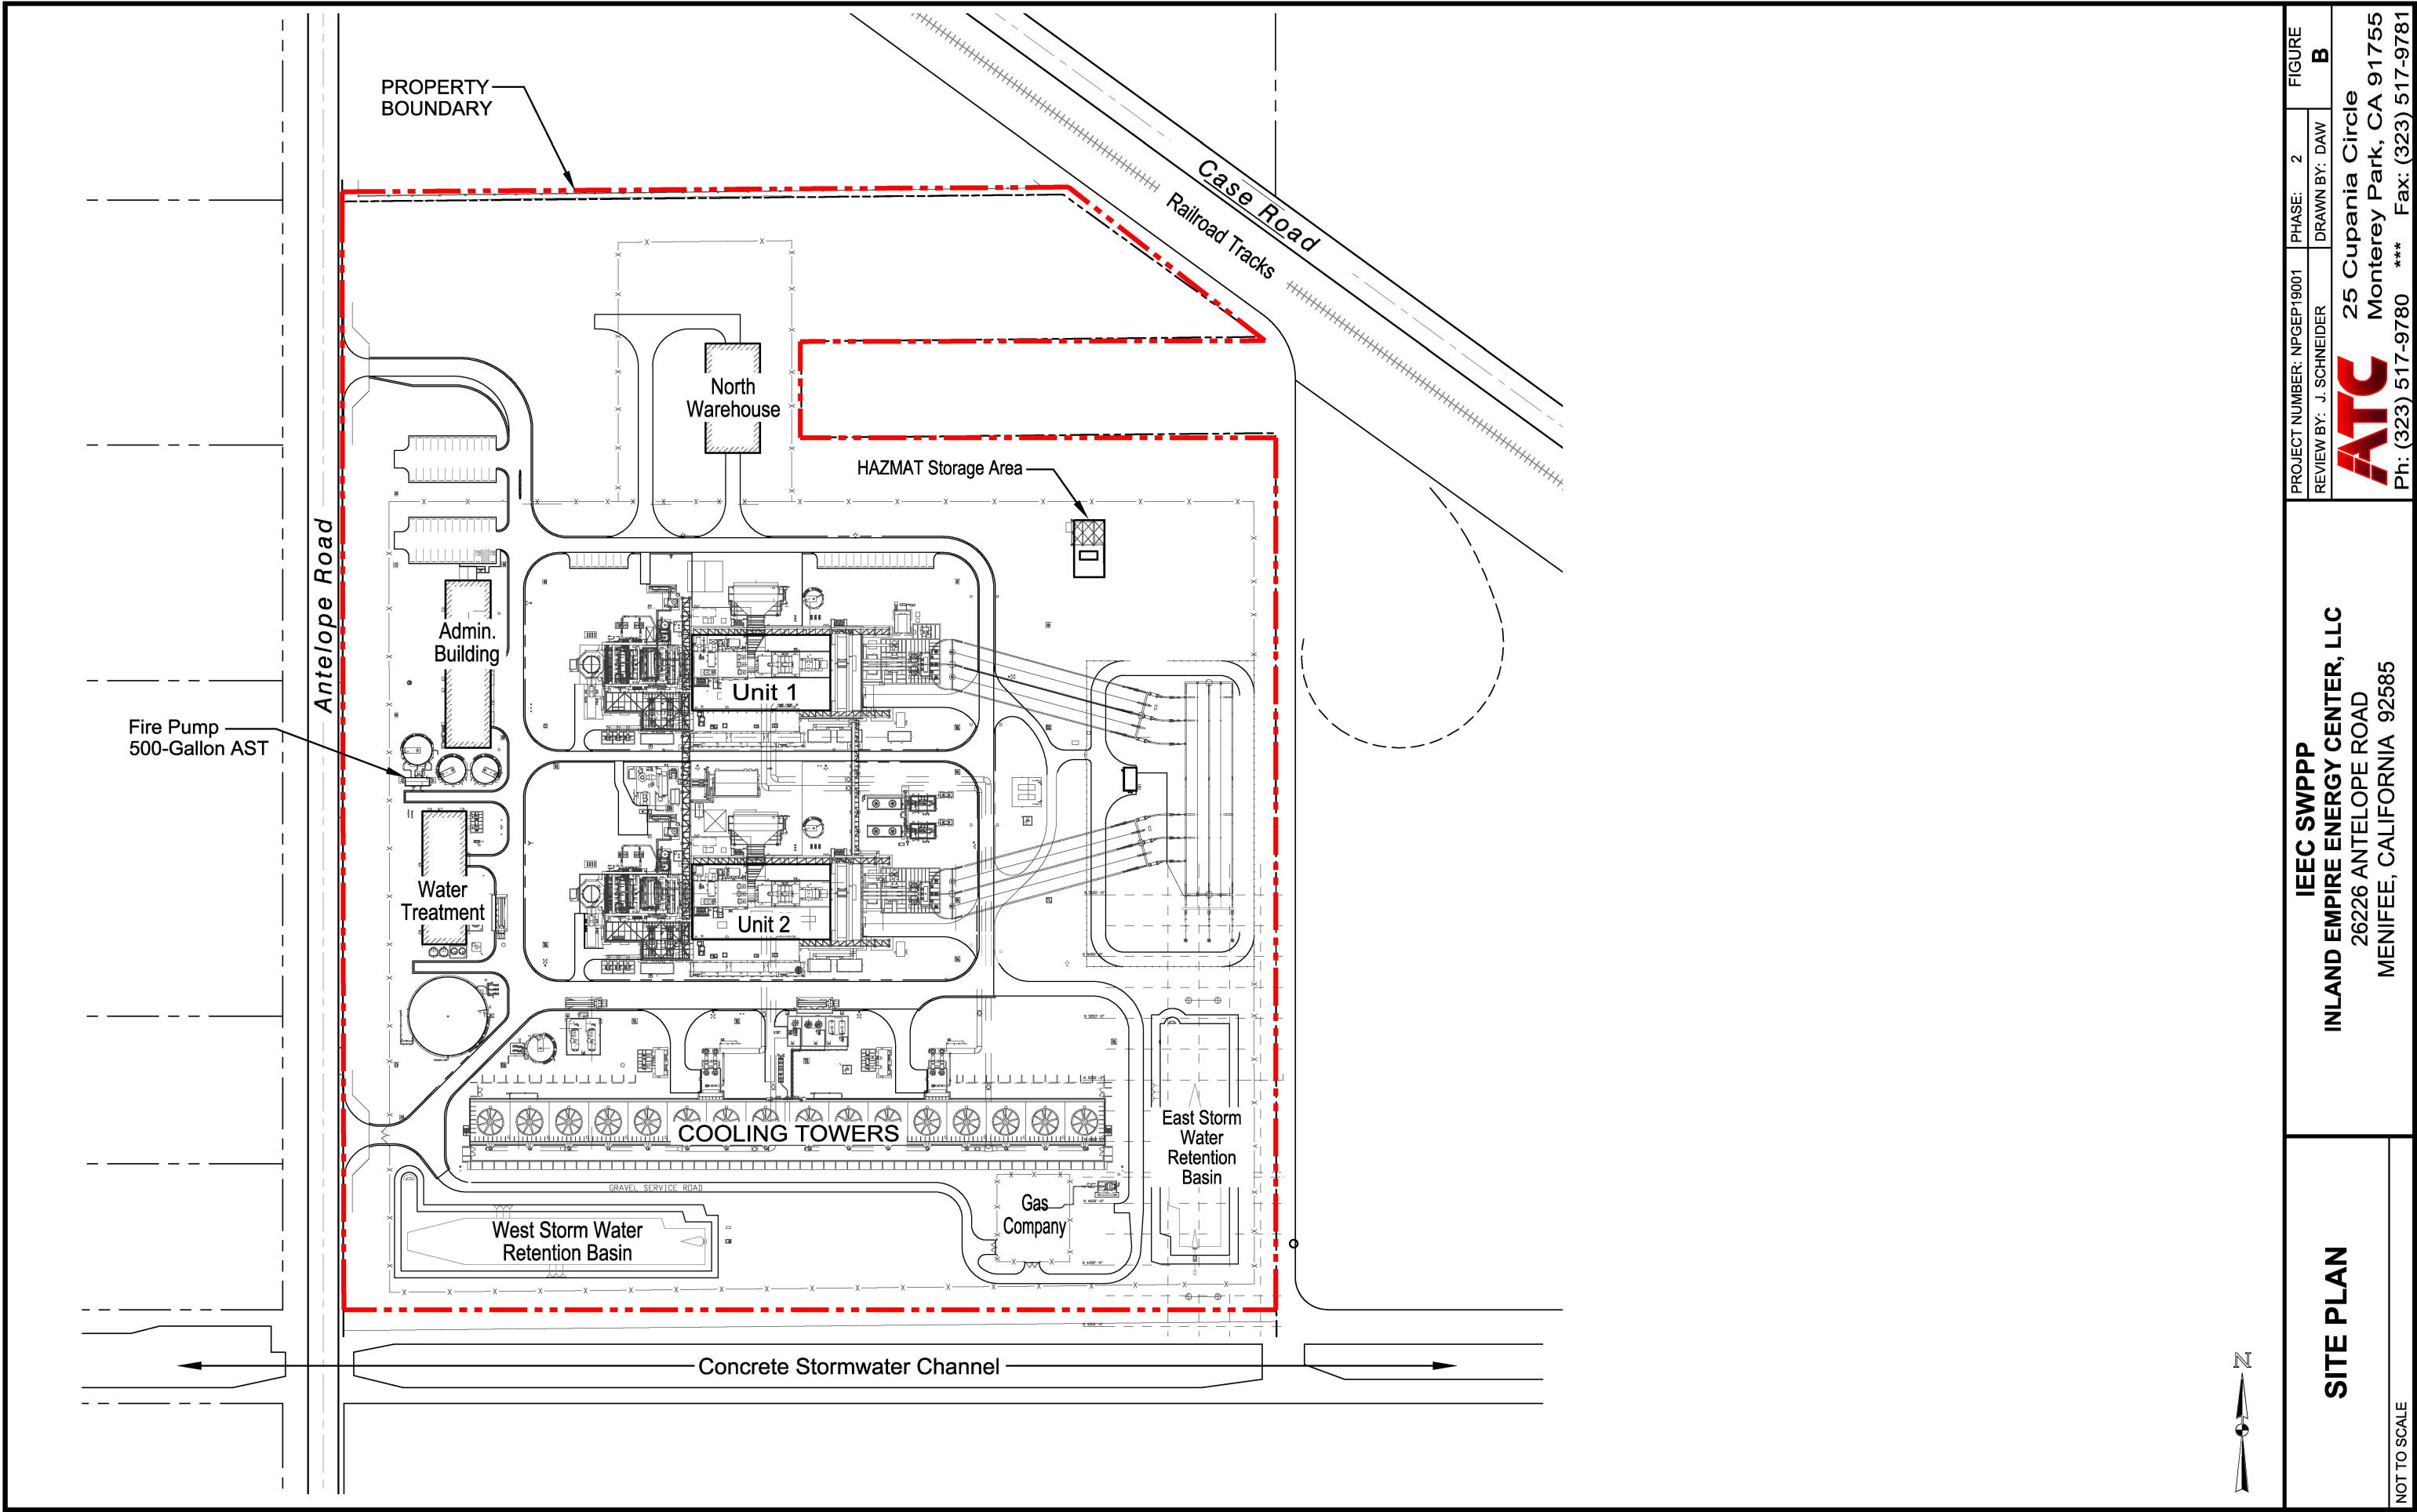


IEEC SWPPP
INLAND EMPIRE ENERGY CENTER, LLC
26226 ANTELOPE ROAD
MENIFEE, CALIFORNIA 92585

SITE PLAN

NOT TO SCALE

PROJECT NUMBER: NPGEP19001	PHASE: 2	FIGURE
REVIEW BY: J. SCHNEIDER	DRAWN BY: DAW	B
ATC 25 Cupania Circle Monterey Park, CA 91755 Ph: (323) 517-9780 *** Fax: (323) 517-9781		

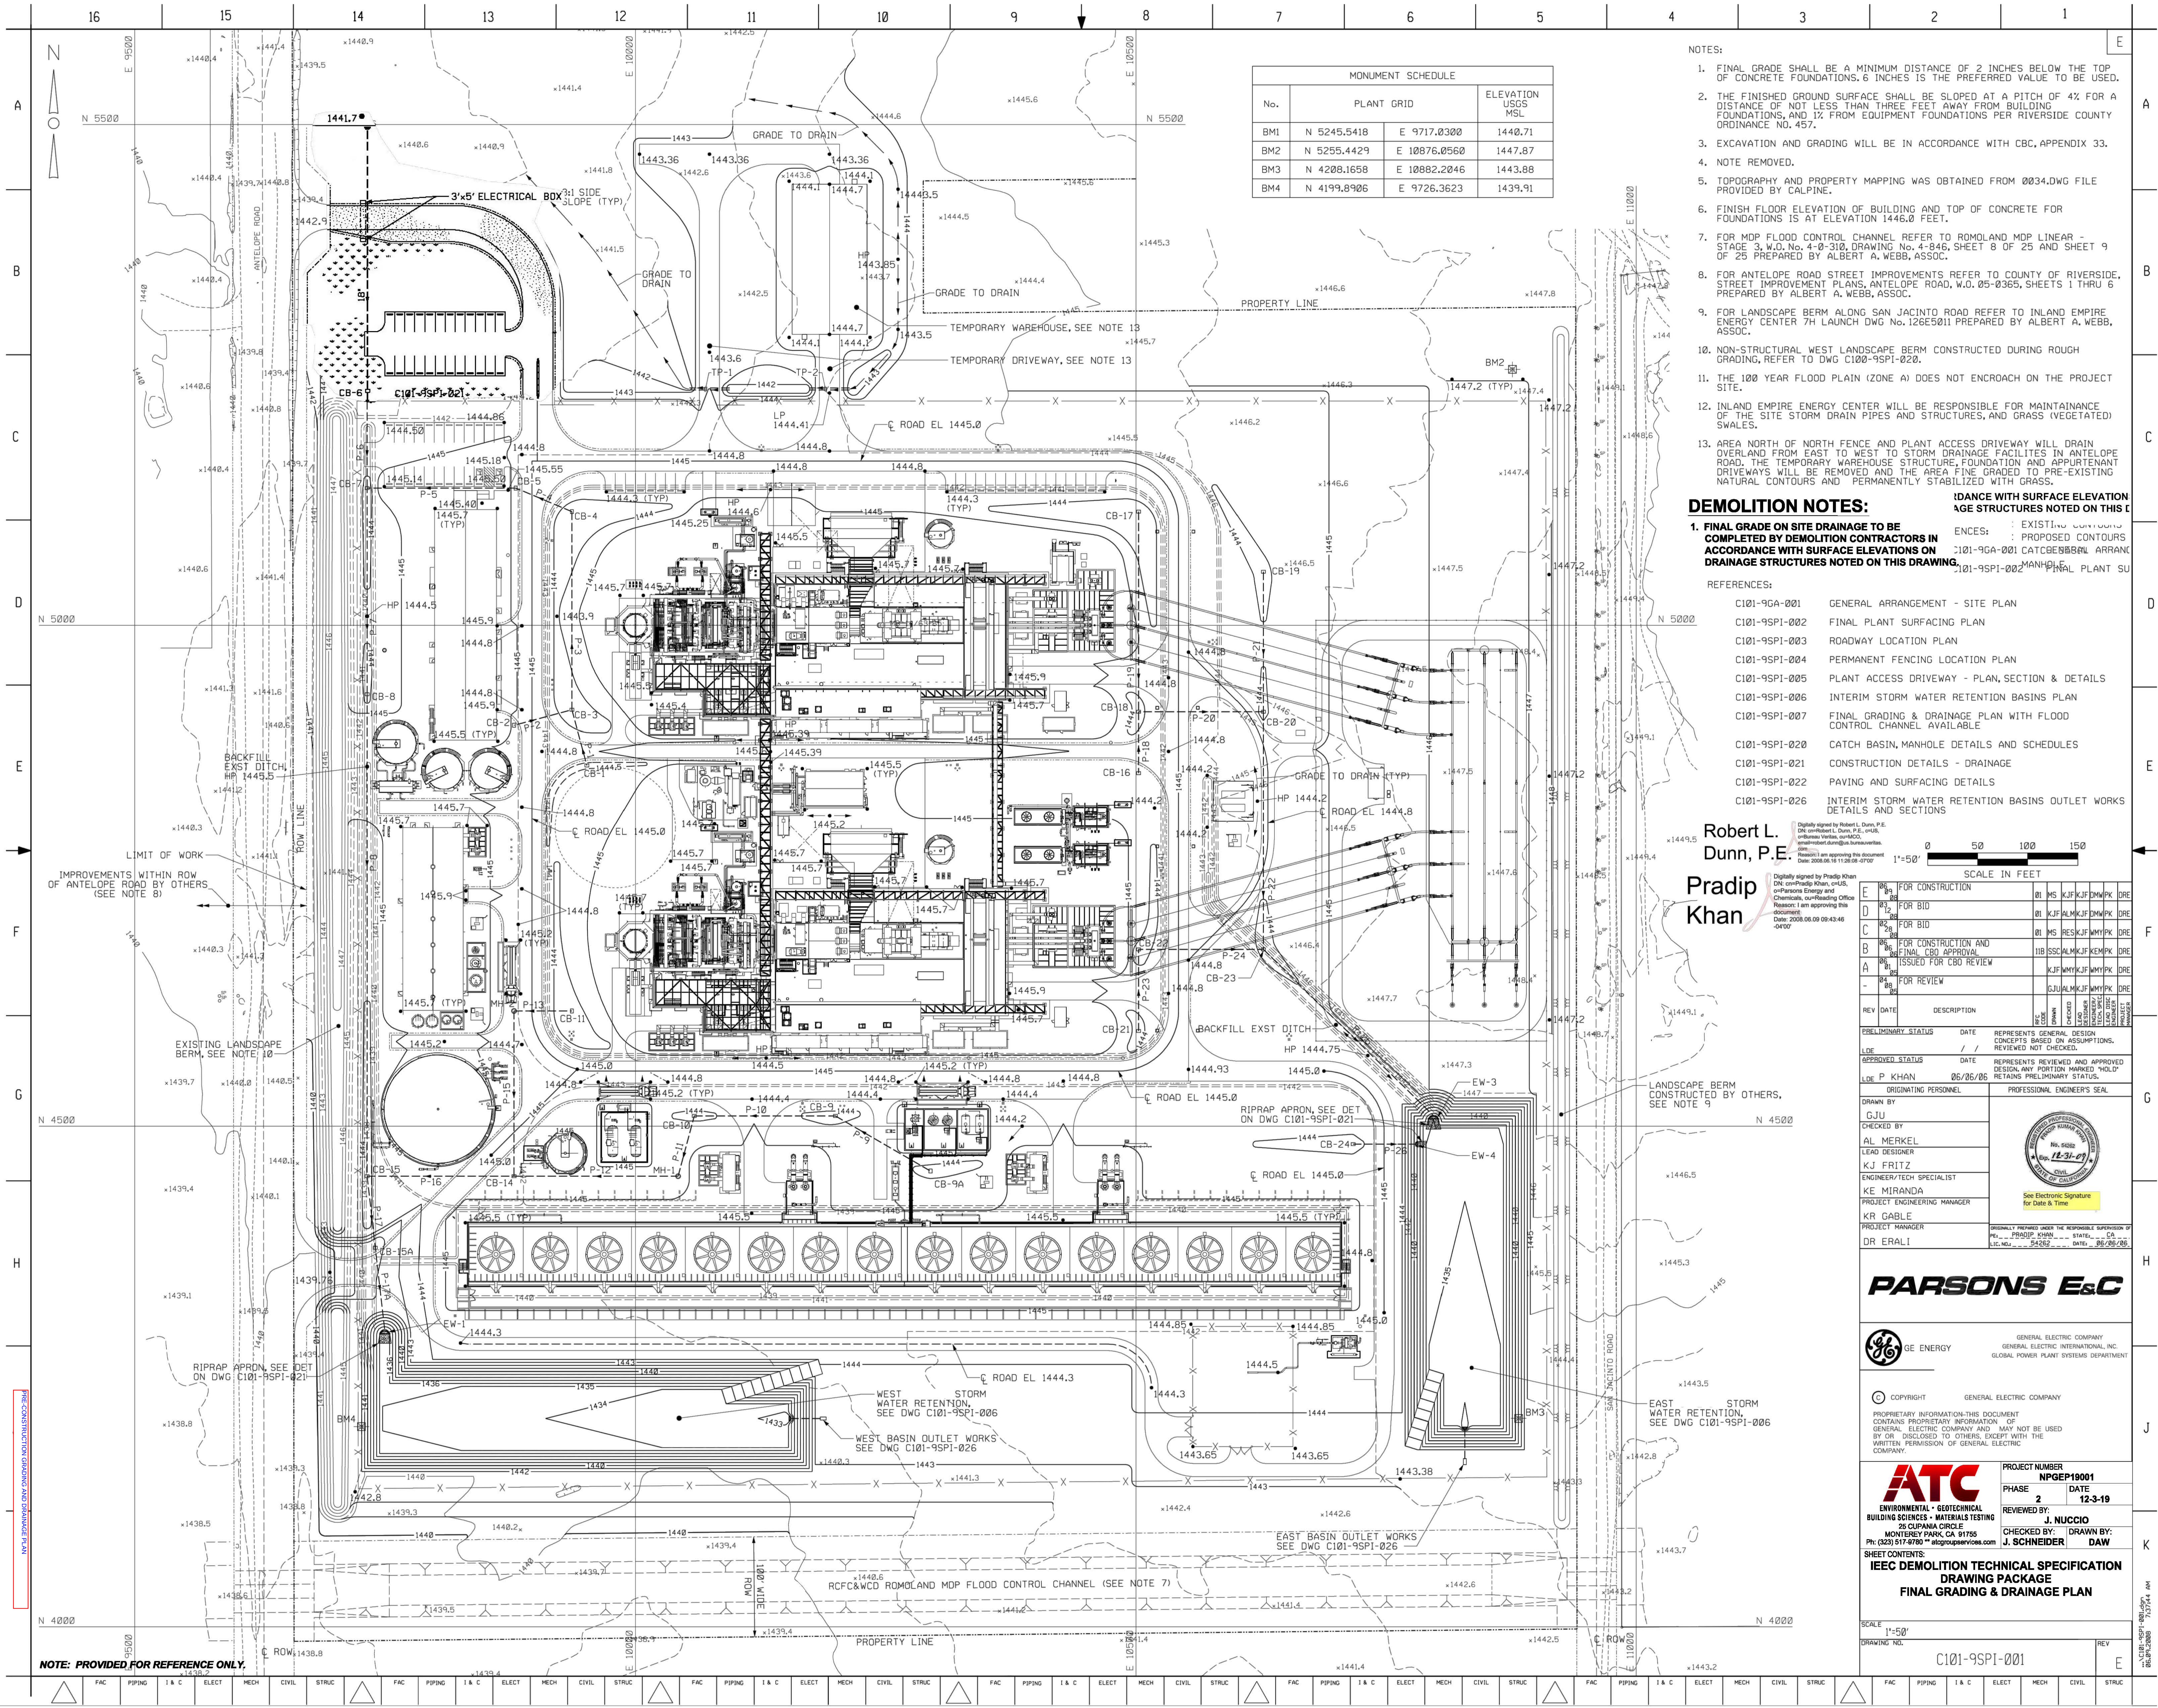

MONUMENT SCHEDULE			
No.	PLANT GRID		ELEVATION USCS MSL
BM1	N 5245.5418	E 9717.0300	1440.71
BM2	N 5255.4429	E 10876.0560	1447.87
BM3	N 4208.1658	E 10882.2046	1443.88
BM4	N 4199.8906	E 9726.3623	1439.91

- NOTES:
1. FINAL GRADE SHALL BE A MINIMUM DISTANCE OF 2 INCHES BELOW THE TOP OF CONCRETE FOUNDATIONS, 6 INCHES IS THE PREFERRED VALUE TO BE USED.
 2. THE FINISHED GROUND SURFACE SHALL BE SLOPED AT A PITCH OF 4% FOR A DISTANCE OF NOT LESS THAN THREE FEET AWAY FROM BUILDING FOUNDATIONS, AND 1% FROM EQUIPMENT FOUNDATIONS PER RIVERSIDE COUNTY ORDINANCE NO. 457.
 3. EXCAVATION AND GRADING WILL BE IN ACCORDANCE WITH CBC, APPENDIX 33.
 4. NOTE REMOVED.
 5. TOPOGRAPHY AND PROPERTY MAPPING WAS OBTAINED FROM 0034.DWG FILE PROVIDED BY CALPINE.
 6. FINISH FLOOR ELEVATION OF BUILDING AND TOP OF CONCRETE FOR FOUNDATIONS IS AT ELEVATION 1446.0 FEET.
 7. FOR MDP FLOOD CONTROL CHANNEL REFER TO ROMOLAND MDP LINEAR STAGE 3, W.D. No. 4-0-310, DRAWING No. 4-846, SHEET 8 OF 25 AND SHEET 9 OF 25 PREPARED BY ALBERT A. WEBB, ASSOC.
 8. FOR ANTELOPE ROAD STREET IMPROVEMENTS REFER TO COUNTY OF RIVERSIDE, STREET IMPROVEMENT PLANS, ANTELOPE ROAD, W.D. 05-0365, SHEETS 1 THRU 6 PREPARED BY ALBERT A. WEBB, ASSOC.
 9. FOR LANDSCAPE BERM ALONG SAN JACINTO ROAD REFER TO INLAND EMPIRE ENERGY CENTER 7H LAUNCH DWG No. 126E5011 PREPARED BY ALBERT A. WEBB, ASSOC.
 10. NON-STRUCTURAL WEST LANDSCAPE BERM CONSTRUCTED DURING ROUGH GRADING, REFER TO DWG C100-9SPI-020.
 11. THE 100 YEAR FLOOD PLAIN (ZONE A) DOES NOT ENCR OACH ON THE PROJECT SITE.
 12. INLAND EMPIRE ENERGY CENTER WILL BE RESPONSIBLE FOR MAINTAINANCE OF THE SITE STORM DRAIN PIPES AND STRUCTURES, AND GRASS (VEGETATED) SWALES.
 13. AREA NORTH OF NORTH FENCE AND PLANT ACCESS DRIVEWAY WILL DRAIN OVERLAND FROM EAST TO WEST TO STORM DRAINAGE FACILITIES IN ANTELOPE ROAD. THE TEMPORARY WAREHOUSE STRUCTURE, FOUNDATION AND APPURTENANT DRIVEWAYS WILL BE REMOVED AND THE AREA FINE GRADED TO PRE-EXISTING NATURAL CONTOURS AND PERMANENTLY STABILIZED WITH GRASS.

DEMOLITION NOTES:

1. FINAL GRADE ON SITE DRAINAGE TO BE COMPLETED BY DEMOLITION CONTRACTORS IN ACCORDANCE WITH SURFACE ELEVATIONS ON DRAINAGE STRUCTURES NOTED ON THIS DRAWING.

2. DEMOLITION OF EXISTING CONTOURS IN ACCORDANCE WITH SURFACE ELEVATIONS ON DRAINAGE STRUCTURES NOTED ON THIS DRAWING.

REFERENCES:	
C101-9GA-001	GENERAL ARRANGEMENT - SITE PLAN
C101-9SPI-002	FINAL PLANT SURFACING PLAN
C101-9SPI-003	ROADWAY LOCATION PLAN
C101-9SPI-004	PERMANENT FENCING LOCATION PLAN
C101-9SPI-005	PLANT ACCESS DRIVEWAY - PLAN, SECTION & DETAILS
C101-9SPI-006	INTERIM STORM WATER RETENTION BASINS PLAN
C101-9SPI-007	FINAL GRADING & DRAINAGE PLAN WITH FLOOD CONTROL CHANNEL AVAILABLE
C101-9SPI-020	CATCH BASIN, MANHOLE DETAILS AND SCHEDULES
C101-9SPI-021	CONSTRUCTION DETAILS - DRAINAGE
C101-9SPI-022	PAVING AND SURFACING DETAILS
C101-9SPI-026	INTERIM STORM WATER RETENTION BASINS OUTLET WORKS DETAILS AND SECTIONS

Robert L. Dunn, P.E.
Pradip Khan

1"=50'

0 50 100 150
SCALE IN FEET

E	06/26/06	FOR CONSTRUCTION	01	MS	KJFKJFJMDWPK	DRE
D	06/26/06	FOR BID	01	KJFKJFKJFJMDWPK	DRE	
C	06/26/06	FOR BID	01	MS	RESKJFKJWMPK	DRE
B	06/26/06	FOR CONSTRUCTION AND FINAL CBO APPROVAL	01B	SSJFK		

PARSONS E&C

GE ENERGY
GENERAL ELECTRIC COMPANY
GLOBAL POWER PLANT SYSTEMS DEPARTMENT

COPYRIGHT GENERAL ELECTRIC COMPANY

PROPRIETARY INFORMATION-THIS DOCUMENT CONTAINS PROPRIETARY INFORMATION OF GENERAL ELECTRIC COMPANY AND MAY NOT BE USED BY OR DISCLOSED TO OTHERS, EXCEPT WITH THE WRITTEN PERMISSION OF GENERAL ELECTRIC COMPANY.

 ENVIRONMENTAL • GEOTECHNICAL BUILDING SCIENCES • MATERIALS TESTING 25 CUPANA CIRCLE MONTEREY PARK, CA 91755 PH: (626) 517-9700 • atcgroupservices.com	PROJECT NUMBER NPGE19001
PHASE 2	DATE 12-3-19
REVIEWED BY: J. NUCCIO	CHECKED BY: J. SCHNEIDER
DRAWN BY: DAW	


SHEET CONTENTS
**IEEC DEMOLITION TECHNICAL SPECIFICATION
DRAWING PACKAGE
FINAL GRADING & DRAINAGE PLAN**

SCALE: 1"=50'

DRAWING NO. C101-9SPI-001

REV

NOTE: PROVIDED FOR REFERENCE ONLY.

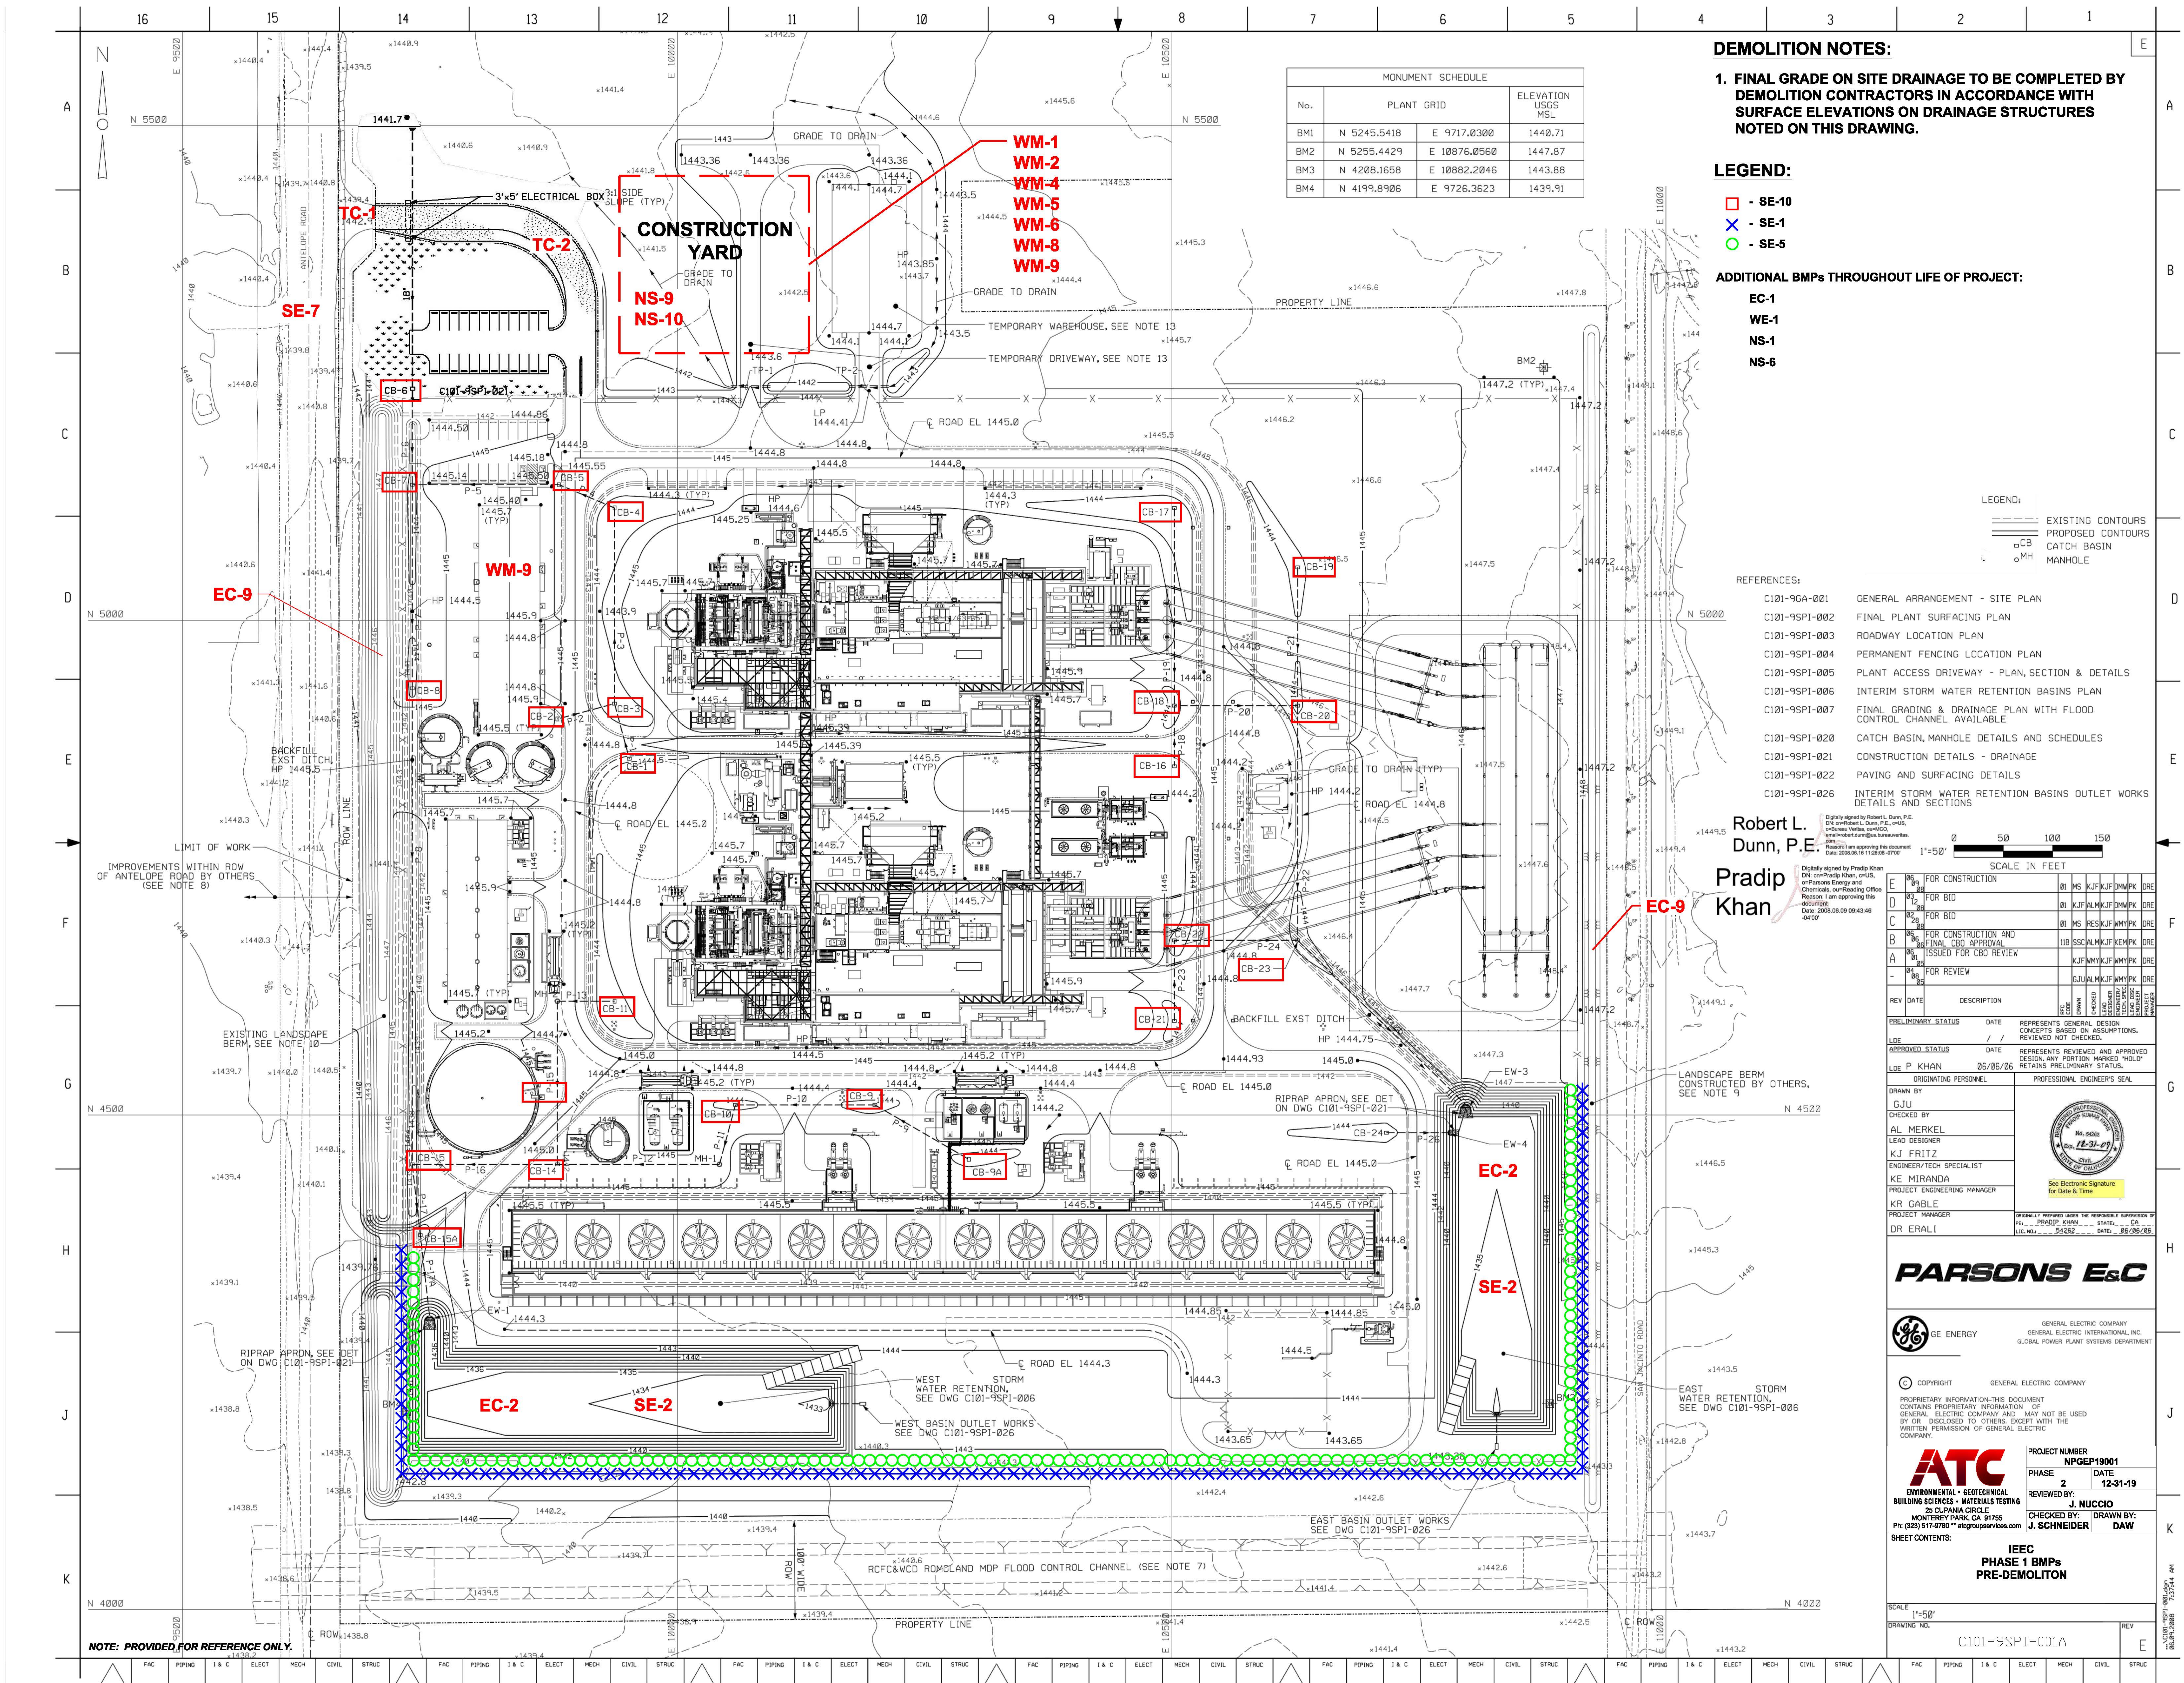

NOTE: PROVIDED FOR REFERENCE ONLY.

MONUMENT SCHEDULE			
No.	PLANT GRID		ELEVATION USGS MSL
BM1	N 5245.5418	E 9717.0300	1440.71
BM2	N 5255.4429	E 10876.0560	1447.87
BM3	N 4208.1658	E 10882.2046	1443.88
BM4	N 4199.8906	E 9726.3623	1439.91

DEMOLITION NOTES:

1. FINAL GRADE ON SITE DRAINAGE TO BE COMPLETED BY DEMOLITION CONTRACTORS IN ACCORDANCE WITH SURFACE ELEVATIONS ON DRAINAGE STRUCTURES NOTED ON THIS DRAWING.

LEGEND:

- SE-10
- SE-1
- SE-5

ADDITIONAL BMPs THROUGHOUT LIFE OF PROJECT:

- EC-1
- WE-1
- NS-1
- NS-6

- LEGEND:
- EXISTING CONTOURS
 - PROPOSED CONTOURS
 - CATCH BASIN
 - MANHOLE

- REFERENCES:
- C101-9GA-001 GENERAL ARRANGEMENT - SITE PLAN
 - C101-9SPI-002 FINAL PLANT SURFACING PLAN
 - C101-9SPI-003 ROADWAY LOCATION PLAN
 - C101-9SPI-004 PERMANENT FENCING LOCATION PLAN
 - C101-9SPI-005 PLANT ACCESS DRIVEWAY - PLAN, SECTION & DETAILS
 - C101-9SPI-006 INTERIM STORM WATER RETENTION BASINS PLAN
 - C101-9SPI-007 FINAL GRADING & DRAINAGE PLAN WITH FLOOD CONTROL CHANNEL AVAILABLE
 - C101-9SPI-020 CATCH BASIN, MANHOLE DETAILS AND SCHEDULES
 - C101-9SPI-021 CONSTRUCTION DETAILS - DRAINAGE
 - C101-9SPI-022 PAVING AND SURFACING DETAILS
 - C101-9SPI-026 INTERIM STORM WATER RETENTION BASINS OUTLET WORKS DETAILS AND SECTIONS

Robert L. Dunn, P.E.
Pradip Khan

Scale in feet: 0, 50, 100, 150

1"=50'

REV	DATE	DESCRIPTION	BY	CHKD	APP'D
1	06/26/06	FOR CONSTRUCTION	MS	KJF	DMW/PK
2	06/26/06	FOR BID	MS	KJF	DMW/PK
3	06/26/06	FOR BID	MS	RES	KJF/DMW/PK
4	06/26/06	FOR CONSTRUCTION AND FINAL CBO APPROVAL	MS	SSA	KJF/DMW/PK
5	06/26/06	ISSUED FOR CBO REVIEW	MS	KJF	DMW/PK
6	06/26/06	FOR REVIEW	MS	SJA	KJF/DMW/PK
7	06/26/06	FOR REVIEW	MS	SJA	KJF/DMW/PK

PRELIMINARY STATUS	DATE	REPRESENTS GENERAL DESIGN CONCEPTS BASED ON ASSUMPTIONS. REVIEWED NOT CHECKED.
LDE	06/26/06	
APPROVED STATUS	DATE	REPRESENTS REVIEWED AND APPROVED DESIGN. ANY PORTION MARKED "HOLD" RETAINS PRELIMINARY STATUS.
LDE	06/26/06	

ORIGINATING PERSONNEL	PROFESSIONAL ENGINEER'S SEAL
DRAWN BY: CJU	
CHECKED BY: AL MERKEL	
LEAD DESIGNER: KJ FRITZ	
ENGINEERING SPECIALIST: KE MIRANDA	
PROJECT ENGINEERING MANAGER: KR GABLE	
PROJECT MANAGER: DR ERALI	

PARSONS E&C

GE ENERGY

GENERAL ELECTRIC COMPANY

GENERAL ELECTRIC INTERNATIONAL INC.

GLOBAL POWER PLANT SYSTEMS DEPARTMENT

PROJECT NUMBER: NPGE19001

PHASE: 2

DATE: 12-31-19

REVIEWED BY: J. NUCCIO

CHECKED BY: J. SCHNEIDER

DRAWN BY: DAW

ATC

ENVIRONMENTAL • GEOTECHNICAL BUILDING SCIENCES • MATERIALS TESTING

2500 PULPANA CIRCLE

MONTEREY PARK, CA 91755

Ph: (623) 517-0780


IEEC

PHASE 1 BMPs

PRE-DEMOLITION

SCALE: 1"=50'

DRAWING NO.: C101-9SPI-001A

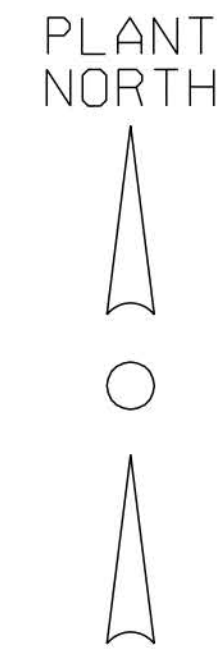

N 5200'-0"

E 16000'-0"

E 9600'-0"

E 10200'-0"

E 10200'-0"

E 10400'-0"

E 10500'-0"

GENERAL NOTES:

1. [] INDICATES THE LAST THREE DIGITS OF THE ENLARGED COMPOSITE PLAN. ACTUAL DRAWING NUMBER IS PRECEDED WITH M301-9UGC-
2. THIS DRAWING TO BE WORKED IN CONJUNCTION WITH THE PIPING ISOMETRIC DRAWINGS.
3. FOR GENERAL ARRANGEMENT SITE PLAN SEE DRAWING NO. M001-9GA-001.
4. ALL COORDINATES SHOWN ARE PLANT DESIGN.
5. ALL FOUNDATIONS ARE SHOWN AS REFERENCE.
6. ALL ELECTRICAL DUCTBANKS ARE SHOWN AS REFERENCE.
7. THIS DRAWING TO BE WORKED IN CONJUNCTION WITH THE PIPING QUANTITIES LIST AND THE FITTINGS LIST.

DEMOLITION NOTES:


1. REMOVE ALL UNDERGROUND PIPING WITHIN 12' OF GRADE SURFACE WITH THE EXCEPTION OF:
 - POTABLE WATER (PW)
 - FIRE PROTECTION (FP)
 - STORM SEWER
2. IF PIPING IS PRESENT BELOW 12' FROM GRADE SURFACE CUT, PLUG AND CAP AT 12' BGS IN ACCORDANCE WITH REQUIREMENTS DETAILED IN TECHNICAL SPECIFICATIONS.



Scott Alan Bolles
Bolles

REV	DATE	DESCRIPTION	DESIGNED	CHECKED	LEAD	IN CHARGE	PROJECT MANAGER	PROJECT ENGINEER
E 26	05/15/05	ISSUED FOR REISSUE REQUEST	JKG	DSW	SAB	DSW	SAB	DSW
D 25	05/15/05	GENERAL UPDATE AND ISSUE	JKG	DSW	SAB	DSW	SAB	DSW
C 24	05/15/05	ISSUED FOR CBO REVIEW	JKG	DSW	SAB	DSW	SAB	DSW
B 23	05/15/05	UPDATED FOR UNDERGROUND PIPING PACKAGE	JKG	DSW	SAB	DSW	SAB	DSW
A 22	05/15/05	PRELIMINARY - ISSUED FOR INFORMATION ONLY	MFP	DSW	SAB	DSW	SAB	DSW
-	05/15/05	PRELIMINARY - FOR BIDDING PURPOSE ONLY	JKG	DSW	SAB	DSW	SAB	DSW
REV	DATE	DESCRIPTION	DESIGNED	CHECKED	LEAD	IN CHARGE	PROJECT MANAGER	PROJECT ENGINEER
PRELIMINARY STATUS	DATE	REPRESENTS GENERAL DESIGN CONCEPTS BASED ON ASSUMPTIONS.						
APPROVED STATUS	DATE	REPRESENTS REVIEWED AND APPROVED DESIGN. ANY PORTION MARKED "HOLD" RETAINS PRELIMINARY STATUS.						
ORIGINATING PERSONNEL	PROFESSIONAL ENGINEER'S SEAL							
DRAWN BY	J.K.G.							
CHECKED BY								
LEAD DESIGNER	D.S. WEAVER							
ENGINEER/TECH SPECIALIST								
PROJECT ENGINEERING MANAGER	K.R. GABEL							
PROJECT MANAGER	D.R. ERALI							
ORIGINALLY PREPARED UNDER THE RESPONSIBLE SUPERVISION OF			REV.	DATE	STATE	DATE		
			REV.	DATE	STATE	DATE		

PARSONS E&C

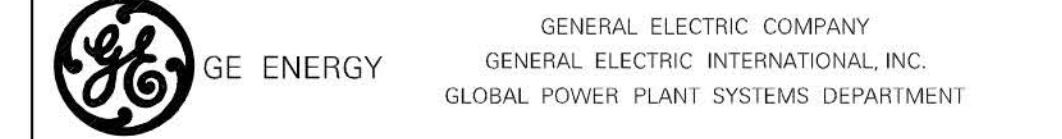

© COPYRIGHT 2005 GENERAL ELECTRIC COMPANY


PROPRIETARY INFORMATION-THIS DOCUMENT CONTAINS PROPRIETARY INFORMATION OF GENERAL ELECTRIC COMPANY AND MAY NOT BE USED BY OR DISCLOSED TO OTHERS, EXCEPT WITH THE WRITTEN PERMISSION OF GENERAL ELECTRIC COMPANY.

ATC ENVIRONMENTAL • GEOTECHNICAL BUILDING SCIENCES • MATERIALS TESTING 26 CLIPPAVA CIRCLE MONTEREY PARK, CA 91706 PH: (923) 917-9780 ***atcgroupservices.com	PROJECT NUMBER	NPGE19001
	PHASE	2
	DATE	12-9-19
	REVIEWED BY:	J. NUCCIO
SHEET CONTENTS: IEEC DEMOLITION TECHNICAL SPECIFICATION DRAWING PACKAGE UNDERGROUND PIPING COMPOSITE KEY PLAN	CHECKED BY:	J. SCHNEIDER
	DRAWN BY:	DAW

SCALE	1"=40'
DRAWING NO.	M301-9UGC-001
REV	E


FILE NAME: m301ugc001.dgn
PATH: c:\p7\unland\draw\ugc\p7\m301ugc001.dgn
SERVER: p7s01087

NOTE: PROVIDED FOR REFERENCE ONLY.

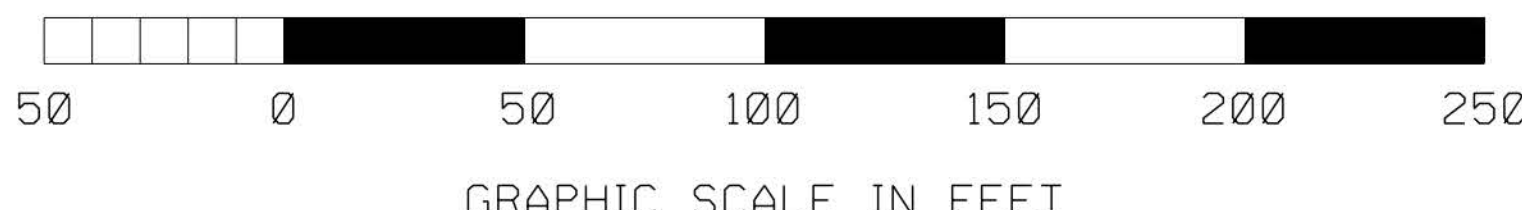

FAC	PIPING	I & C	ELECT	MECH	CIVIL	STRUC	FAC	PIPING	I & C	ELECT	MECH	CIVIL	STRUC	FAC	PIPING	I & C	ELECT	MECH	CIVIL	STRUC	FAC	PIPING	I & C	ELECT	MECH	CIVIL	STRUC	FAC	PIPING	I & C	ELECT	MECH	CIVIL	STRUC
-----	--------	-------	-------	------	-------	-------	-----	--------	-------	-------	------	-------	-------	-----	--------	-------	-------	------	-------	-------	-----	--------	-------	-------	------	-------	-------	-----	--------	-------	-------	------	-------	-------

VHL: Wld Mod 24 16:01:23 2006

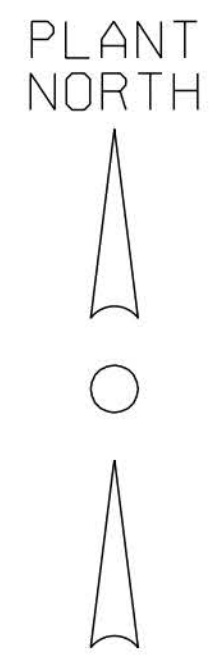

NOTES:
1. FOR GENERAL NOTES SEE DRAWING
NUMBER M301-9UGC-001.

- DEMOLITION NOTES:**
1. REMOVE ALL UNDERGROUND PIPING WITHIN 12' OF GRADE SURFACE WITH THE EXCEPTION OF:
 - POTABLE WATER (PW)
 - FIRE PROTECTION (FP)
 - STORM SEWER
 2. IF PIPING IS PRESENT BELOW 12' FROM GRADE SURFACE CUT, PLUG AND CAP AT 12' BGS IN ACCORDANCE WITH REQUIREMENTS DETAILED IN TECHNICAL SPECIFICATIONS.


- TO REMAIN

- TO BE REMOVED



E 26 05/15/05 GE DRAWING REISSUE REQUEST			JKG	DSW	SAB 02	DRE
D 10 05/15/05	GENERAL UPDATE AND ISSUE FOR CBO REVIEW		JKG	DSW	SAB 11A	DRE
C 11 03/02	ISSUED FOR CBO REVIEW		JKG	DSW	SAB 11A	DRE
B 06 05/15/05	UPDATED FOR UNDERGROUND BID PACKAGE		JKG	DSW	SAB	DRE
A 04 05/15/05	PRELIMINARY - ISSUED FOR INFORMATION ONLY		RKG	DSW	SAB	DRE
05/15/05	PRELIMINARY - FOR BIDDING PURPOSE ONLY		JKG	DSW	SAB	DRE
REV DATE	DESCRIPTION		DESIGNED	CHECKED	LEAD	PROJECT
			DESIGNED	CHECKED	LEAD	PROJECT
PRELIMINARY STATUS DATE			REPRESENTS GENERAL DESIGN CONCEPTS BASED ON ASSUMPTIONS. REVIEWED NOT CHECKED			
LDE S.A. BOLLES 05/15/05						
APPROVED STATUS DATE			REPRESENTS REVIEWED AND APPROVED DESIGN. ANY PORTION MARKED "HOLD" RETAINS PRELIMINARY STATUS.			
LDE						
ORIGINATING PERSONNEL			PROFESSIONAL ENGINEER'S SEAL			
DRAWN BY			J.K.G.			
CHECKED BY						
LEAD DESIGNER			D.S. WEAVER			
ENGINEER/TECH SPECIALIST						
PROJECT ENGINEERING MANAGER			K.R. GABEL			
PROJECT MANAGER			D.R. ERALI			
ORIGINALLY PREPARED UNDER THE RESPONSIBLE SUPERVISION OF						
REV. DATE STATE DATE						

PARSONS E&C

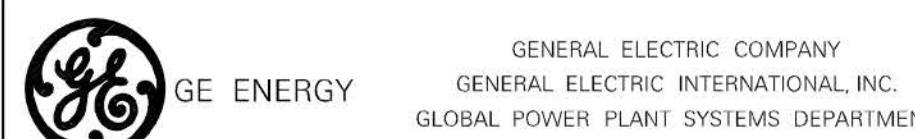

© COPYRIGHT 2005 GENERAL ELECTRIC COMPANY

PROPRIETARY INFORMATION-THIS DOCUMENT
CONTAINS PROPRIETARY INFORMATION OF
GENERAL ELECTRIC COMPANY AND MAY NOT BE USED
BY OR DISCLOSED TO OTHERS, EXCEPT WITH THE
WRITTEN PERMISSION OF GENERAL ELECTRIC
COMPANY.

ATC
ENVIRONMENTAL • GEOTECHNICAL
BUILDING SCIENCES • MATERIALS TESTING
26 CLIPAWA CIRCLE
MONTEREY PARK, CA 91705
PH: (923) 917-9780 ***atcgroupservices.com


PROJECT NUMBER
NPGE19001
PHASE
2
DATE
12-10-19
REVIEWED BY:
J. NUCCIO
CHECKED BY:
J. SCHNEIDER
DRAWN BY:
DAW

SHEET CONTENTS
**IEEC DEMOLITION TECHNICAL SPECIFICATION
DRAWING PACKAGE
UNDERGROUND PIPING COMPOSITE
ENLARGED PLAN**


SCALE
3/32"=1'
DRAWING NO.
M301-9UGC-002

FILE NAME: m301ugc002.dgn
PATH: c:\n\land\draw\ugc\l
SERVER: m301ugc002

NOTE: PROVIDED FOR REFERENCE ONLY.

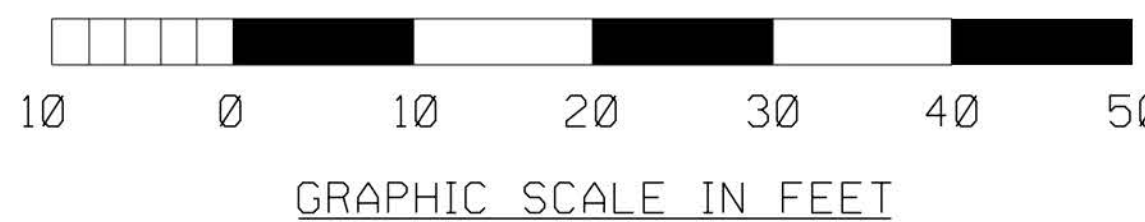



VHL: Wed May 24 15:27:04 2006

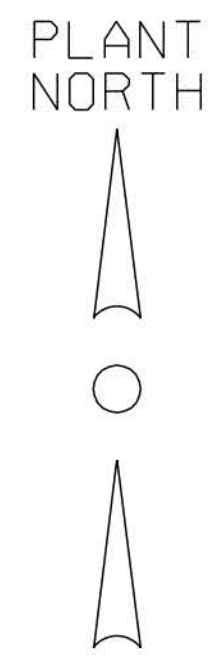

NOTES:
1. FOR GENERAL NOTES SEE DRAWING
NUMBER M301-9UGC-001.

DEMOLITION NOTES:

1. REMOVE ALL UNDERGROUND PIPING WITHIN 12' OF GRADE SURFACE WITH THE EXCEPTION OF:
 - POTABLE WATER (PW)
 - FIRE PROTECTION (FP)
 - STORM SEWER
2. IF PIPING IS PRESENT BELOW 12' FROM GRADE SURFACE CUT, PLUG AND CAP AT 12' BGS IN ACCORDANCE WITH REQUIREMENTS DETAILED IN TECHNICAL SPECIFICATIONS.

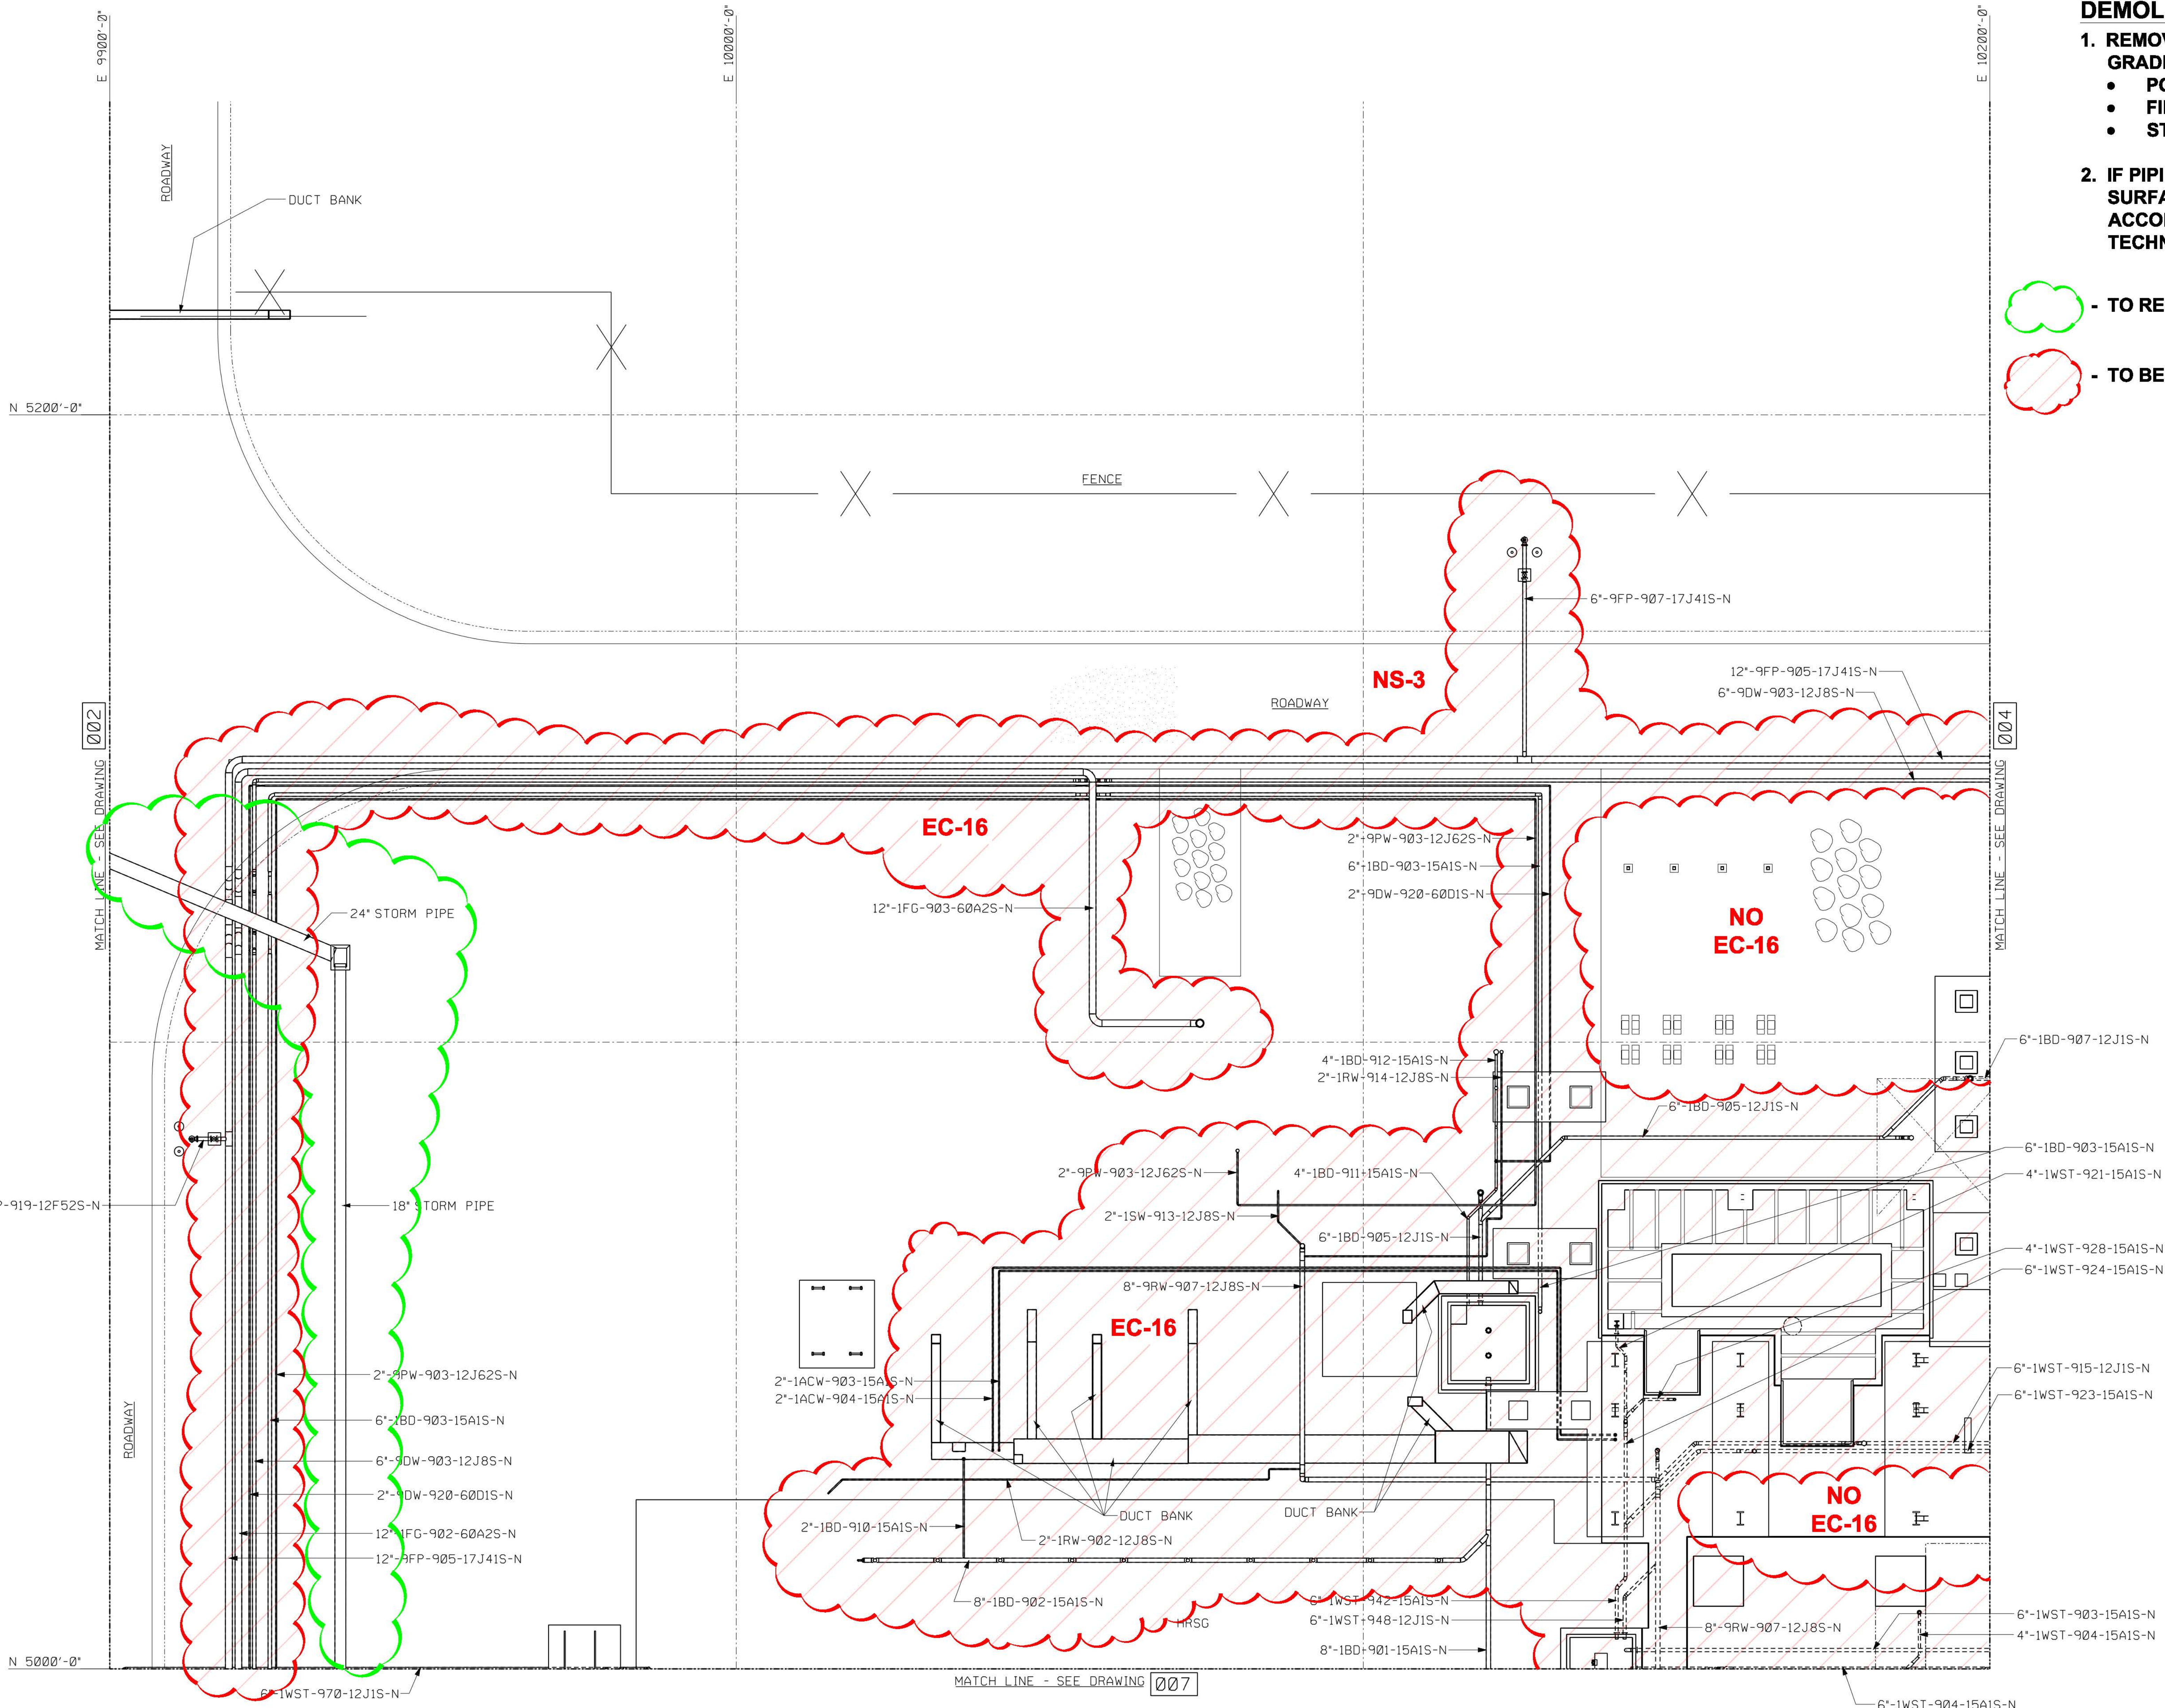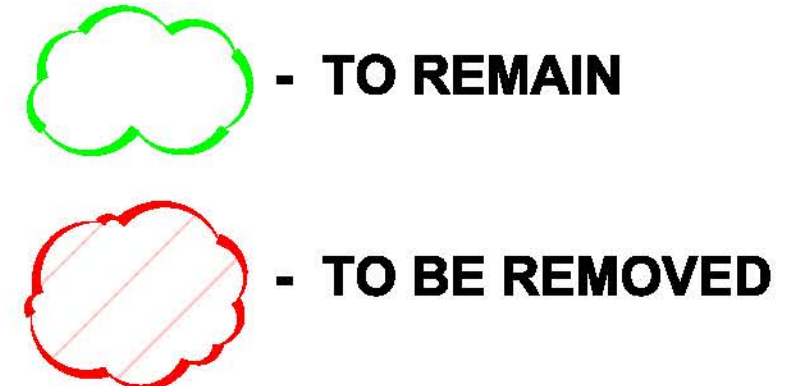

REV	DATE	DESCRIPTION	DESIGNED	CHECKED	LEAD	DESIGNED	CHECKED	LEAD	DESIGNED	CHECKED	LEAD
1	05/15/05	PRELIMINARY STATUS	JKG	DSW	SAB	DSW	SAB	DSW	SAB	DSW	SAB
2	05/15/05	GENERAL UPDATE AND ISSUE	JKG	DSW	SAB	DSW	SAB	DSW	SAB	DSW	SAB
3	05/15/05	ISSUED FOR CBO REVIEW	JKG	DSW	SAB	DSW	SAB	DSW	SAB	DSW	SAB
4	05/15/05	ISSUED FOR CBO REVIEW	JKG	DSW	SAB	DSW	SAB	DSW	SAB	DSW	SAB
5	05/15/05	ISSUED FOR CBO REVIEW	JKG	DSW	SAB	DSW	SAB	DSW	SAB	DSW	SAB
6	05/15/05	ISSUED FOR CBO REVIEW	JKG	DSW	SAB	DSW	SAB	DSW	SAB	DSW	SAB
7	05/15/05	ISSUED FOR CBO REVIEW	JKG	DSW	SAB	DSW	SAB	DSW	SAB	DSW	SAB
8	05/15/05	ISSUED FOR CBO REVIEW	JKG	DSW	SAB	DSW	SAB	DSW	SAB	DSW	SAB
9	05/15/05	ISSUED FOR CBO REVIEW	JKG	DSW	SAB	DSW	SAB	DSW	SAB	DSW	SAB
10	05/15/05	ISSUED FOR CBO REVIEW	JKG	DSW	SAB	DSW	SAB	DSW	SAB	DSW	SAB
11	05/15/05	ISSUED FOR CBO REVIEW	JKG	DSW	SAB	DSW	SAB	DSW	SAB	DSW	SAB
12	05/15/05	ISSUED FOR CBO REVIEW	JKG	DSW	SAB	DSW	SAB	DSW	SAB	DSW	SAB
13	05/15/05	ISSUED FOR CBO REVIEW	JKG	DSW	SAB	DSW	SAB	DSW	SAB	DSW	SAB
14	05/15/05	ISSUED FOR CBO REVIEW	JKG	DSW	SAB	DSW	SAB	DSW	SAB	DSW	SAB
15	05/15/05	ISSUED FOR CBO REVIEW	JKG	DSW	SAB	DSW	SAB	DSW	SAB	DSW	SAB
16	05/15/05	ISSUED FOR CBO REVIEW	JKG	DSW	SAB	DSW	SAB	DSW	SAB	DSW	SAB
17	05/15/05	ISSUED FOR CBO REVIEW	JKG	DSW	SAB	DSW	SAB	DSW	SAB	DSW	SAB
18	05/15/05	ISSUED FOR CBO REVIEW	JKG	DSW	SAB	DSW	SAB	DSW	SAB	DSW	SAB
19	05/15/05	ISSUED FOR CBO REVIEW	JKG	DSW	SAB	DSW	SAB	DSW	SAB	DSW	SAB
20	05/15/05	ISSUED FOR CBO REVIEW	JKG	DSW	SAB	DSW	SAB	DSW	SAB	DSW	SAB
21	05/15/05	ISSUED FOR CBO REVIEW	JKG	DSW	SAB	DSW	SAB	DSW	SAB	DSW	SAB
22	05/15/05	ISSUED FOR CBO REVIEW	JKG	DSW	SAB	DSW	SAB	DSW	SAB	DSW	SAB
23	05/15/05	ISSUED FOR CBO REVIEW	JKG	DSW	SAB	DSW	SAB	DSW	SAB	DSW	SAB
24	05/15/05	ISSUED FOR CBO REVIEW	JKG	DSW	SAB	DSW	SAB	DSW	SAB	DSW	SAB
25	05/15/05	ISSUED FOR CBO REVIEW	JKG	DSW	SAB	DSW	SAB	DSW	SAB	DSW	SAB
26	05/15/05	ISSUED FOR CBO REVIEW	JKG	DSW	SAB	DSW	SAB	DSW	SAB	DSW	SAB
27	05/15/05	ISSUED FOR CBO REVIEW	JKG	DSW	SAB	DSW	SAB	DSW	SAB	DSW	SAB
28	05/15/05	ISSUED FOR CBO REVIEW	JKG	DSW	SAB	DSW	SAB	DSW	SAB	DSW	SAB
29	05/15/05	ISSUED FOR CBO REVIEW	JKG	DSW	SAB	DSW	SAB	DSW	SAB	DSW	SAB
30	05/15/05	ISSUED FOR CBO REVIEW	JKG	DSW	SAB	DSW	SAB	DSW	SAB	DSW	SAB
31	05/15/05	ISSUED FOR CBO REVIEW	JKG	DSW	SAB	DSW	SAB	DSW	SAB	DSW	SAB
32	05/15/05	ISSUED FOR CBO REVIEW	JKG	DSW	SAB	DSW	SAB	DSW	SAB	DSW	SAB
33	05/15/05	ISSUED FOR CBO REVIEW	JKG	DSW	SAB	DSW	SAB	DSW	SAB	DSW	SAB
34	05/15/05	ISSUED FOR CBO REVIEW	JKG	DSW	SAB	DSW	SAB	DSW	SAB	DSW	SAB
35	05/15/05	ISSUED FOR CBO REVIEW	JKG	DSW	SAB	DSW	SAB	DSW	SAB	DSW	SAB
36	05/15/05	ISSUED FOR CBO REVIEW	JKG	DSW	SAB	DSW	SAB	DSW	SAB	DSW	SAB
37	05/15/05	ISSUED FOR CBO REVIEW	JKG	DSW	SAB	DSW	SAB	DSW	SAB	DSW	SAB
38	05/15/05	ISSUED FOR CBO REVIEW	JKG	DSW	SAB	DSW	SAB	DSW	SAB	DSW	SAB
39	05/15/05	ISSUED FOR CBO REVIEW	JKG	DSW	SAB	DSW	SAB	DSW	SAB	DSW	SAB
40	05/15/05	ISSUED FOR CBO REVIEW	JKG	DSW	SAB	DSW	SAB	DSW	SAB	DSW	SAB
41	05/15/05	ISSUED FOR CBO REVIEW	JKG	DSW	SAB	DSW	SAB	DSW	SAB	DSW	SAB
42	05/15/05	ISSUED FOR CBO REVIEW	JKG	DSW	SAB	DSW	SAB	DSW	SAB	DSW	SAB
43	05/15/05	ISSUED FOR CBO REVIEW	JKG	DSW	SAB	DSW	SAB	DSW	SAB	DSW	SAB
44	05/15/05	ISSUED FOR CBO REVIEW	JKG	DSW	SAB	DSW	SAB	DSW	SAB	DSW	SAB
45	05/15/05	ISSUED FOR CBO REVIEW	JKG	DSW	SAB	DSW	SAB	DSW	SAB	DSW	SAB
46	05/15/05	ISSUED FOR CBO REVIEW	JKG	DSW	SAB	DSW	SAB	DSW	SAB	DSW	SAB
47	05/15/05	ISSUED FOR CBO REVIEW	JKG	DSW	SAB	DSW	SAB	DSW	SAB	DSW	SAB
48	05/15/05	ISSUED FOR CBO REVIEW	JKG	DSW	SAB	DSW	SAB	DSW	SAB	DSW	SAB
49	05/15/05	ISSUED FOR CBO REVIEW	JKG	DSW	SAB	DSW	SAB	DSW	SAB	DSW	SAB
50	05/15/05	ISSUED FOR CBO REVIEW	JKG	DSW	SAB	DSW	SAB	DSW	SAB	DSW	SAB

PARSONS E&C
GENERAL ELECTRIC COMPANY
GENERAL ELECTRIC INTERNATIONAL, INC.
GLOBAL POWER PLANT SYSTEMS DEPARTMENT

ATC
ENVIRONMENTAL • GEOTECHNICAL
BUILDING SCIENCES • MATERIALS TESTING
26 CLIPPAVA CIRCLE
MONTEREY PARK, CA 91706
PH: (923) 917-9780 • atcgroupservices.com

PROJECT NUMBER
NPGE19001
PHASE
2
DATE
12-9-19
REVIEWED BY:
J. NUCCIO
CHECKED BY:
J. SCHENIER
DRAWN BY:
DAW

**IEEC DEMOLITION TECHNICAL SPECIFICATION
DRAWING PACKAGE
UNDERGROUND PIPING COMPOSITE
ENLARGED PLAN**

SCALE
3/32"=1'
DRAWING NO.
M301-9UGC-003

REV
E

NOTE: PROVIDED FOR REFERENCE ONLY.

