




DOCKETED

Docket Number:	09-AFC-05C
Project Title:	Abengoa Mojave Compliance
TN #:	203444-3
Document Title:	Part 2 Nov 2014 Monthly Compliance Report
Description:	N/A
Filer:	Dale Rundquist
Organization:	Abengoa Mojave Solar
Submitter Role:	Applicant
Submission Date:	12/15/2014 11:25:06 AM
Docketed Date:	12/15/2014

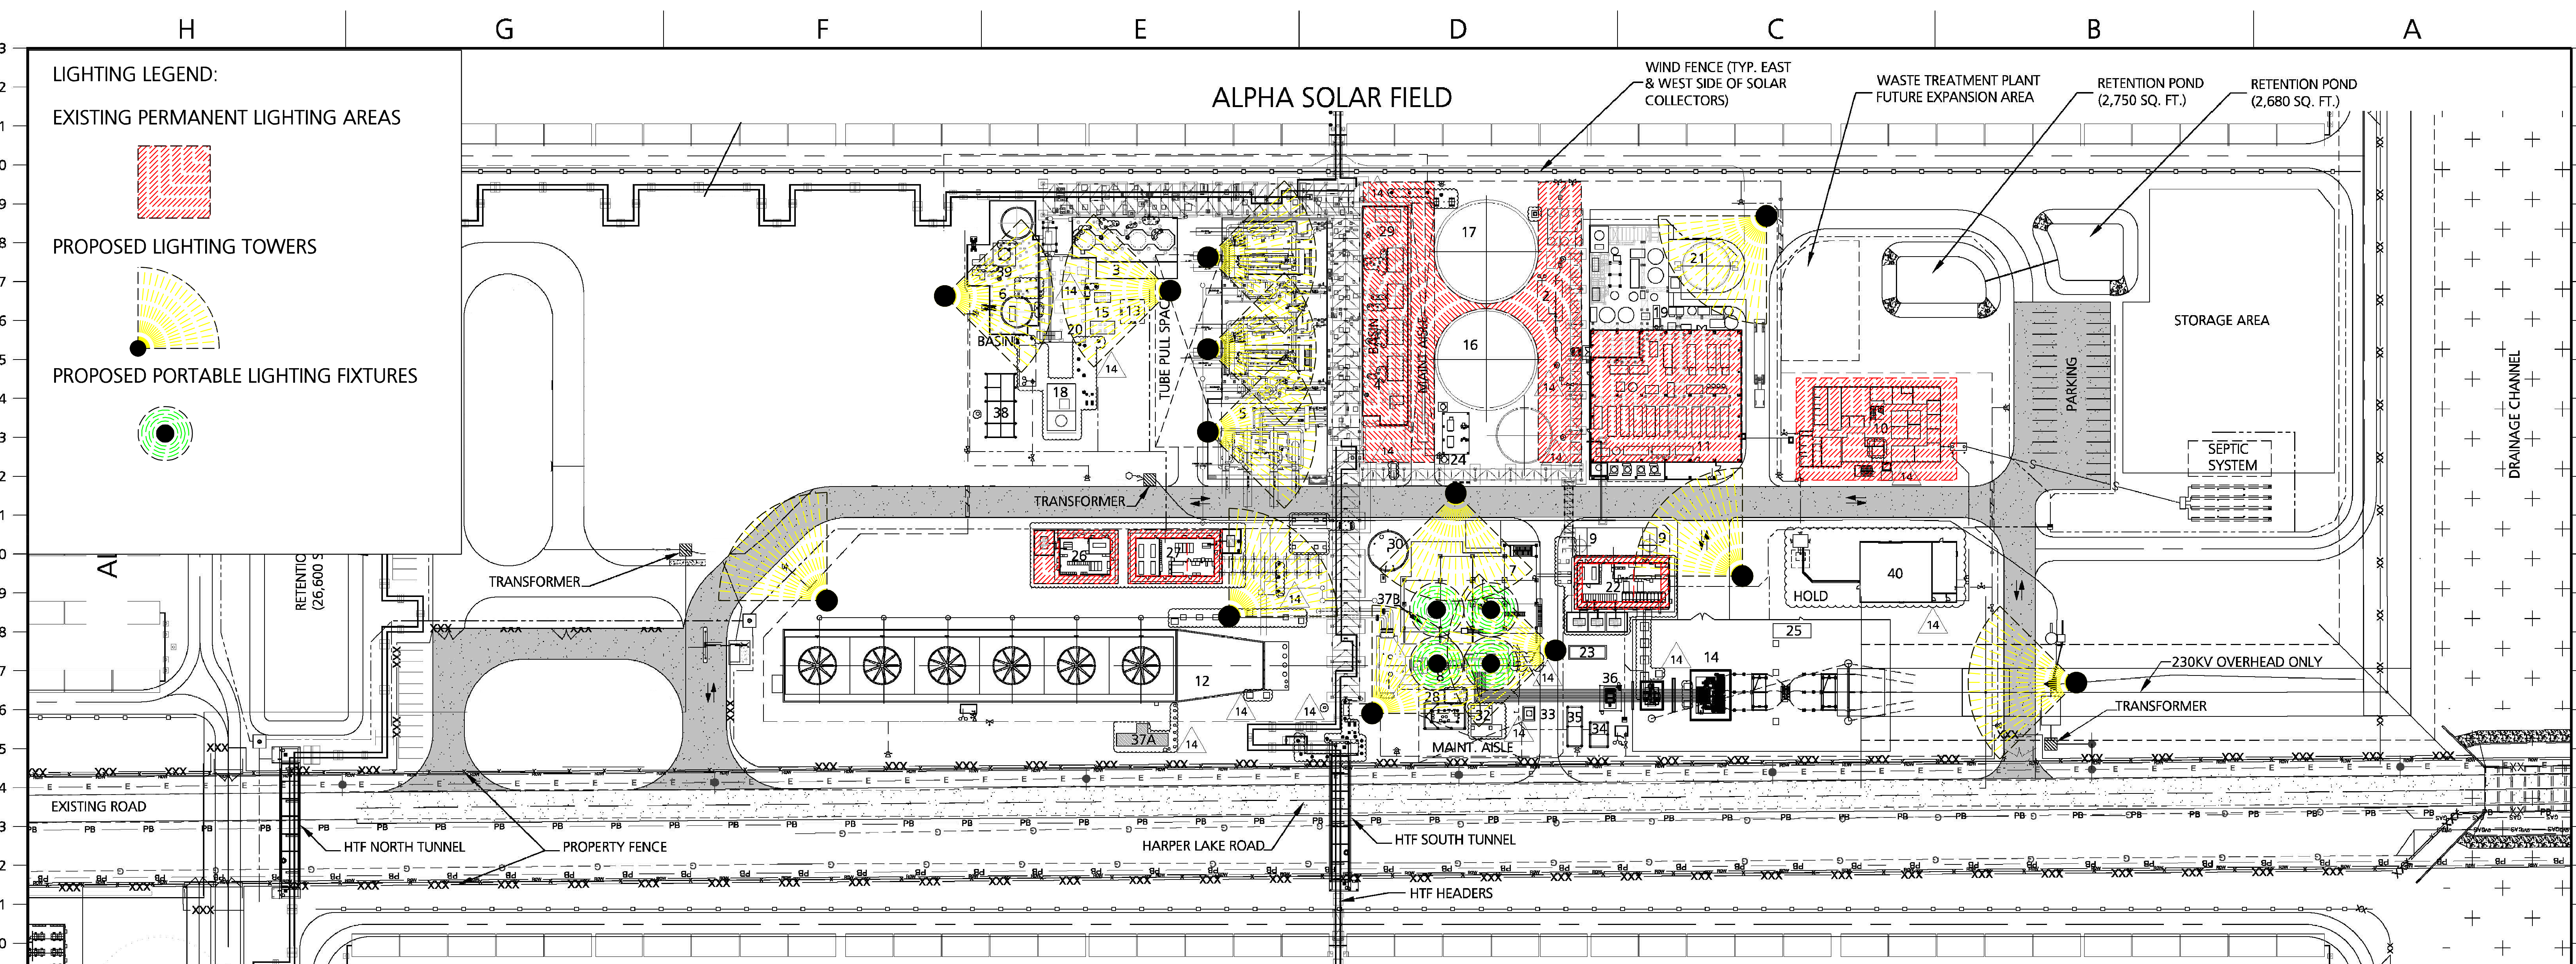

EQUIPMENT LIST					
NUMBER	TAG	DESCRIPTION	NUMBER	TAG	DESCRIPTION
1	A/B-MX-313	Condenser	21	A-MT-451	Polisher Feed Tank
2		Fire Protection System Building	22		Control Electrical Power room
3	A-MV-205A/B/C/E	HTF Expansion Vessels/HTF Expansion Flash Vessel	23		EM Diesel Generator
4	A-MP-200A/B/C/D A-MP-201	HTF Main and Recirculation Pumps	24		Compressed Air System
5		Solar Steam Generator	25		Substation Relay House
6	A-MT-204A/B	HTF Overflow Tanks and Overflow System	26		CT Electrical Building
7		Deaerator and Boiler Feedwater Zone	27		HTF Electrical Building
8	A-MG-301	Steam Turbine Generator	28		Lube Oil Skid
9		Raw Water Production Wells	29	A-MX-208/ A-MV-210	Electric Heater & Strainer Drain Vessel
10		Central E&C and Operation Building (Offices and Maint Shop)	30	A-MT-453	Polished Water Tank
11		Water Treatment Plant Area	31	A-MT-424	Cooling Tower Blowdown Tank
12	A-MM-401A/B/C/D/E/F	Cooling Tower	32		Excitation Compartment
13		Future regeneration system	33		Excitation Transformer
14		Switchyard	34		Battery Compartment
15	A-MF-206A/B/C/D	Carbon filters	35		PEECC-MKVI Interface Outline (GE main electrical building))
16	A-MT-444	Process Make-up Water Tank (Cooling Tower Make-up)	36		Circuit Breaker
17	A-MT-402	Raw/Fire Water Tank	37A/37B		Cooling Tower Chemical Feed System/Boiler Feedwater Chemical System (BFW)
18	A-MZ-207	Nitrogen System	38		Chemical products storage
19	A-MZ-455	Oil Water Separator	39	A-MV-206	HTF/Steam vessel
20		Ullage system	40		Warehouse / Workshop

LEGEND

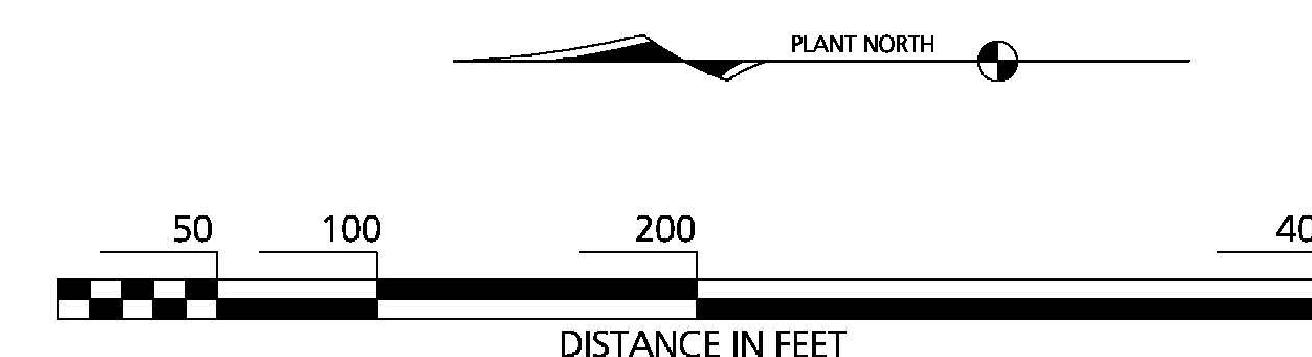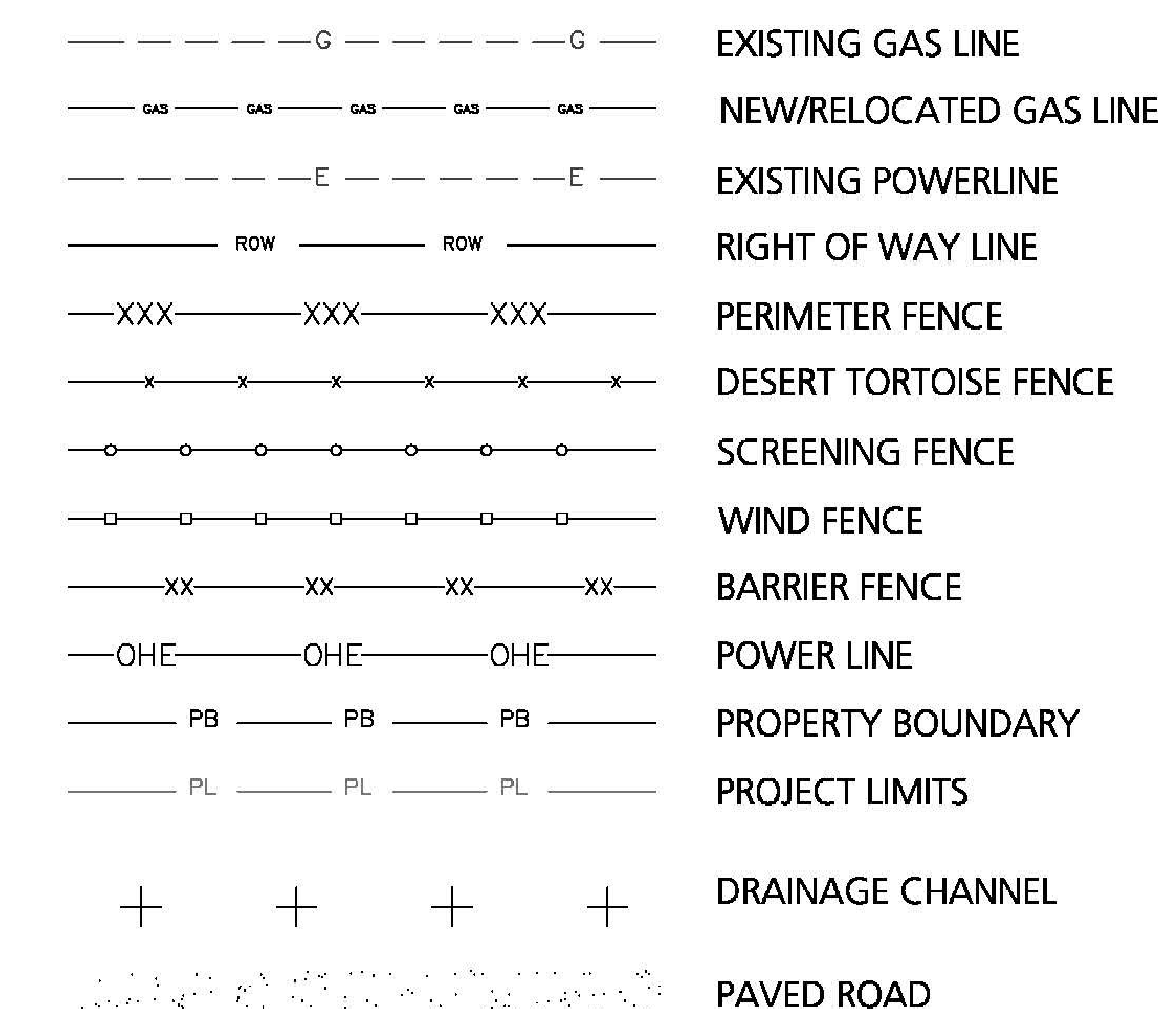

ABEINSA EPC

**ABENER TEYMA
MOJAVE**

ABENGOA SOLAR


CENTRAL PLANT LAYOUT

MOJAVE SOLAR, LLC					HINKLEY, CALIFORNIA	
	BY	DATE	APP'D.	DATE	JOB NO.	REVISION
DRAWN	TEC	13JAN11	TS	13JAN11	120010	
CHECKED	HD	13JAN11	DDC	13JAN11		
SCALE	1" = 60'					

1-03			
DRAWING NUMBER			
6007-PLN-AGE-00-02-L003			



LIGHTING MITIGATION PLAN FOR TCO - ALPHA SITE

THIS DRAWING IS THE PROPERTY OF ABENER TEYMA MOJAVE Information and know-how herein are confidential and proprietary and may not be used, reproduced, or revealed to others except in accordance with the terms of contract with or other written permission of Abener Teyma Mojave General Partnership. Any reproductions in whole or in part including shop drawings shall bear refer to this stamp.	
12/19/13	FOR CONSTRUCTION
ISSUE DATE	PURPOSE OF ISSUE

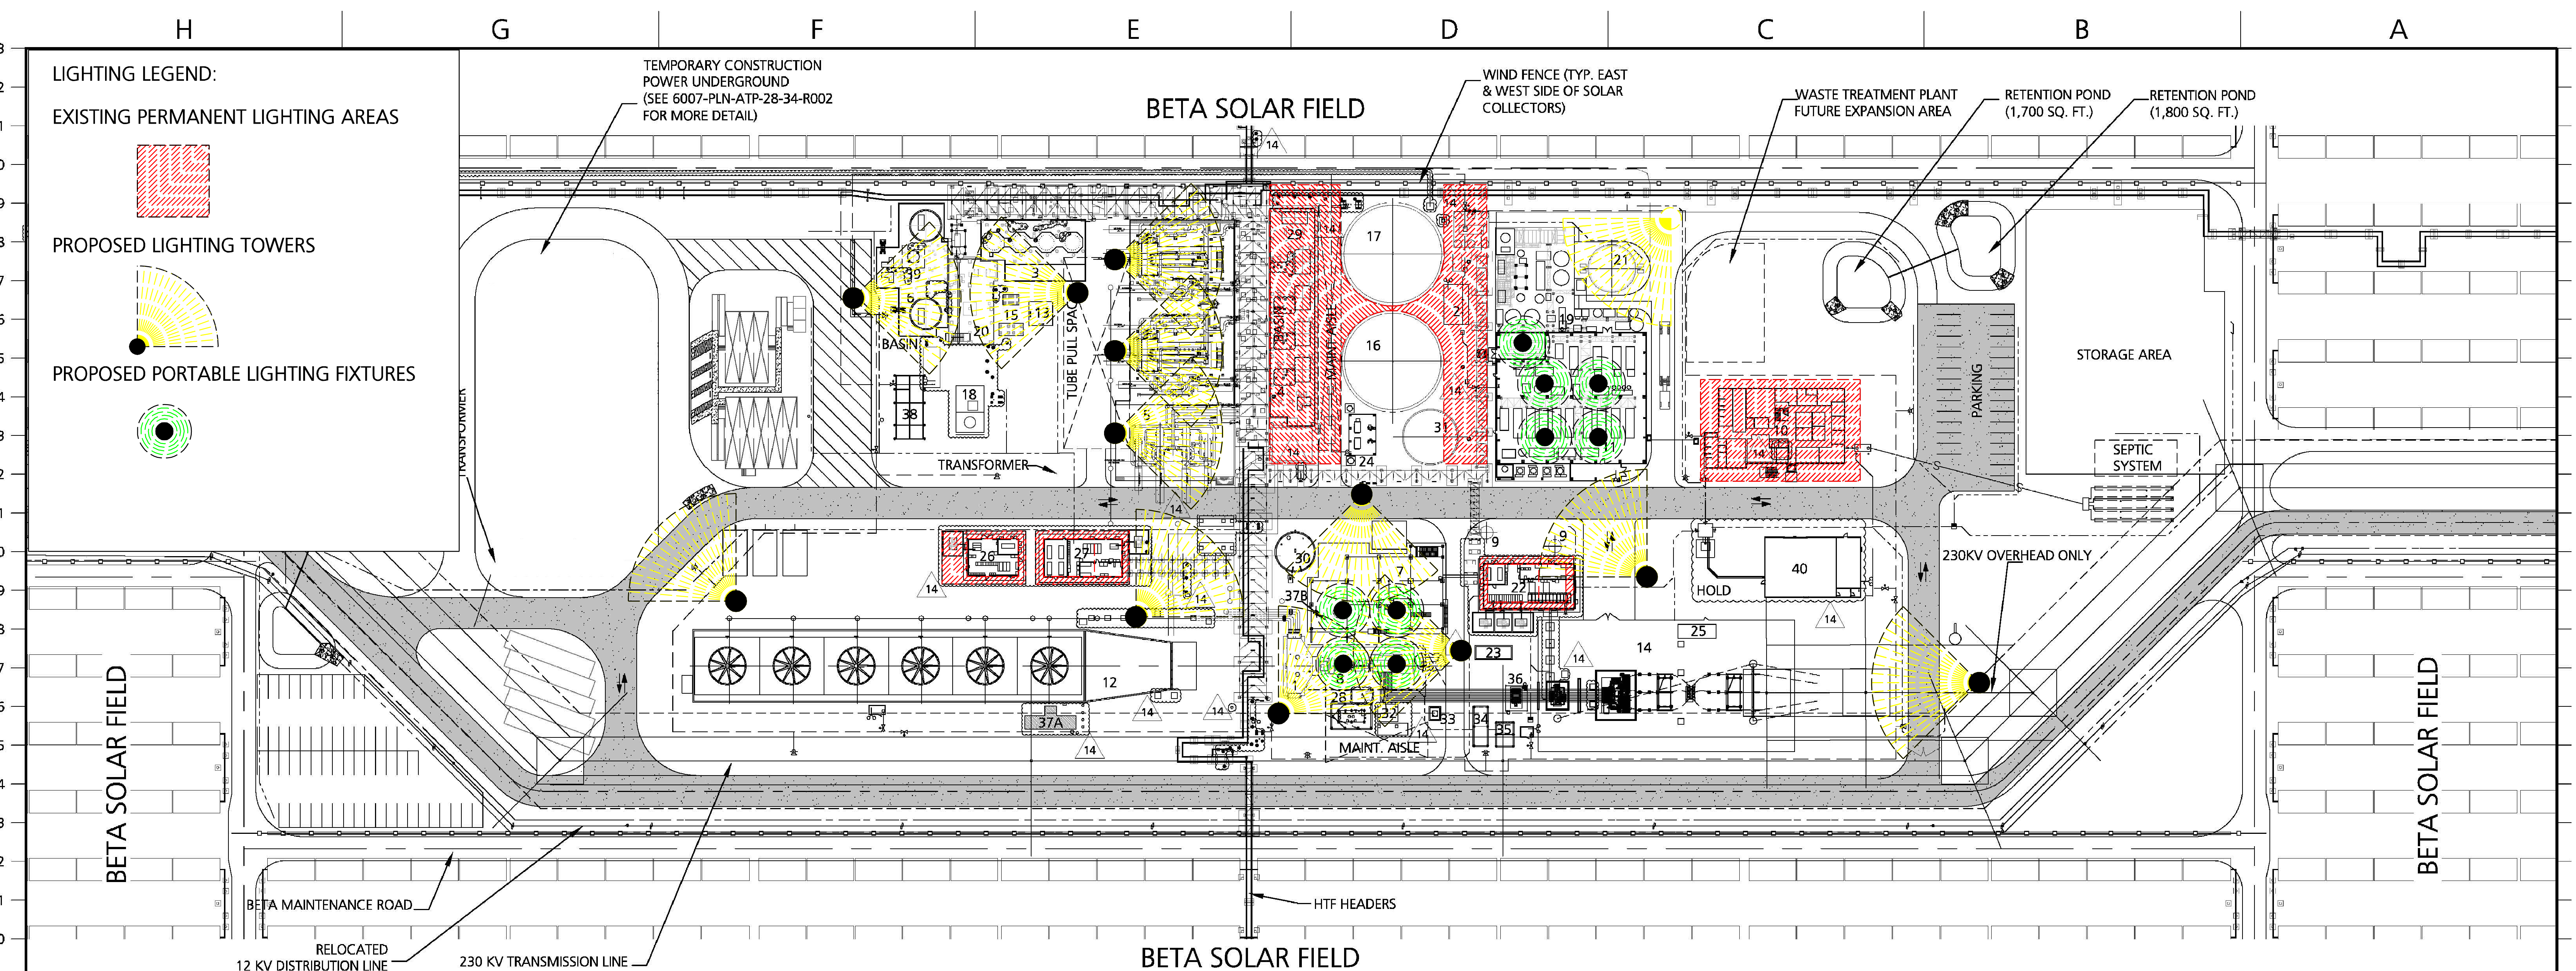

EQUIPMENT LIST					
NUMBER	TAG	DESCRIPTION	NUMBER	TAG	DESCRIPTION
1	B-MX-313	Condenser	21	B-MT-451	Polisher Feed Tank
2		Fire Protection System Building	22		Control Electrical Power room
3	B-MV-205A/B/C/E	HTF Expansion Vessels/HTF Expansion Flash Vessel	23		EM Diesel Generator
4	B-MP-200A/B/C/D A-MP-201	HTF Main and Recirculation Pumps	24		Compressed Air System
5		Solar Steam Generator	25		Substation Relay House
6	B-MT-204A/B	HTF Overflow Tanks and Overflow System	26		CT Electrical Building
7		Deaerator and Boiler Feedwater Zone	27		HTF Electrical Building
8	B-MG-301	Steam Turbine Generator	28		Lube Oil Skid
9		Raw Water Production Wells	29	B-MX-208/ B-MV-210	Electric Heater & Strainer Drain Vessel
10		Central E&C and Operation Building (Offices and Maint Shop)	30	B-MT-453	Polished Water Tank
11		Water Treatment Plant Area	31	B-MT-424	Cooling Tower Blowdown Tank
12	B-MM-401A/B/C/D/E/F	Cooling Tower	32		Excitation Compartment
13		Future regeneration system	33		Excitation Transformer
14		Switchyard	34		Battery Compartment
15	B-MF-206A/B/C/D	Carbon filters	35		PEECC-MKV1 Interface Outline (GE main electrical building))
16	B-MT-444	Process Make-up Water Tank (Cooling Tower Make-up)	36		Circuit Breaker
17	B-MT-402	Raw/Fire Water Tank	37A/37B		Cooling Tower Chemical Feed System/Boiler Feedwater Chemical System (BFW)
18	B-MZ-207	Nitrogen System	38		Chemical products storage
19	B-MZ-455	Oil Water Separator	39	B-MV-206	HTF/Steam vessel
20		Ullage system	40		Warehouse / Workshop

LEGEND

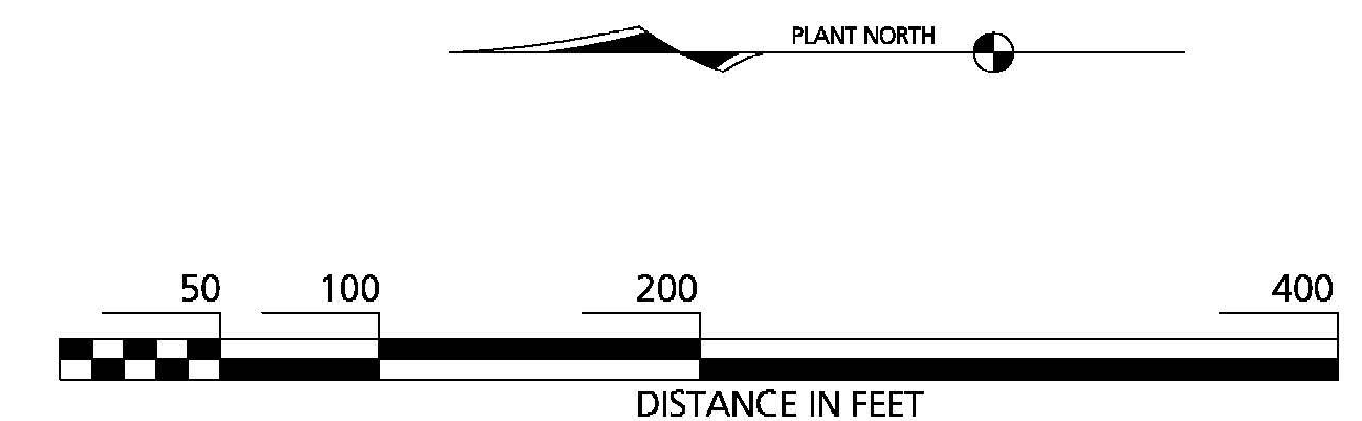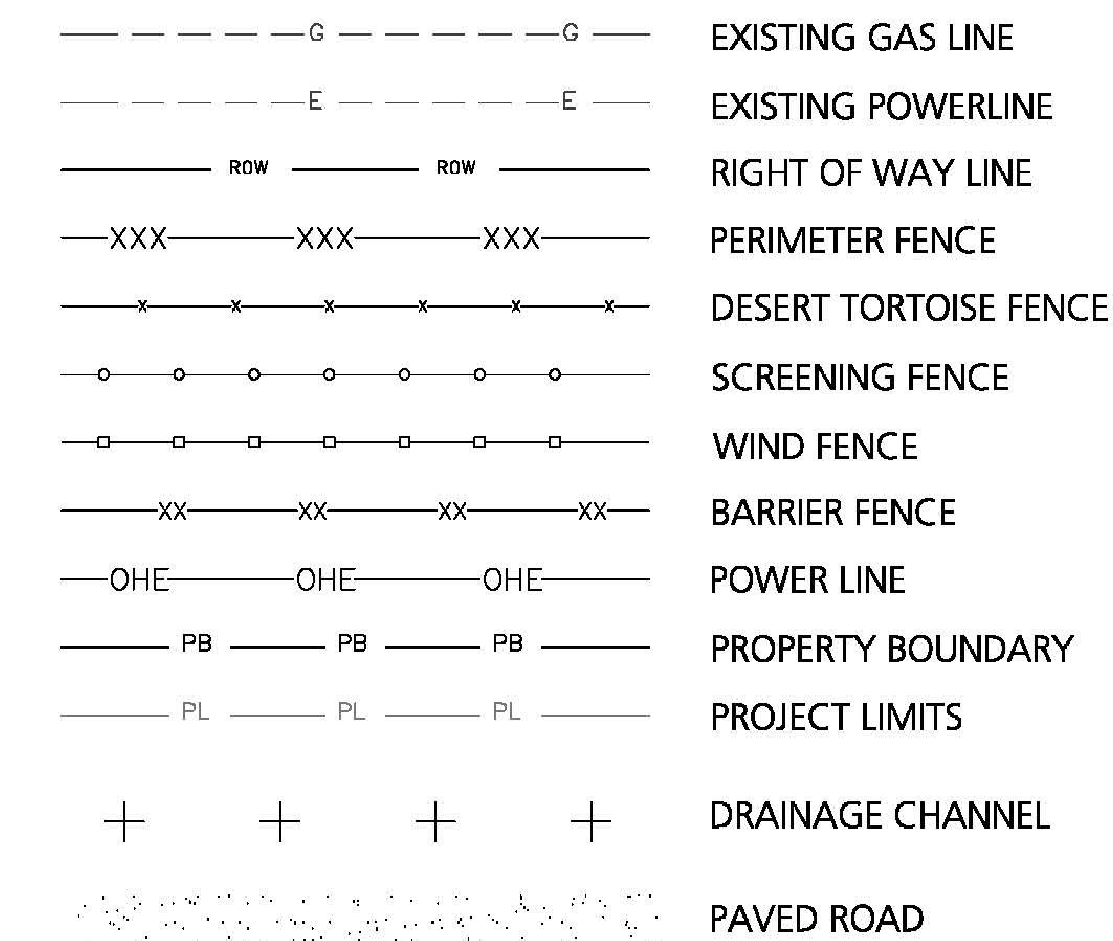

ABEINSA EPC

**ABENER TEYMA
MOJAVE**

ABENGOA SOLAR

CENTRAL PLANT LAYOUT
BETA PLANT

MOJAVE SOLAR, LLC					HINKLEY, CALIFORNIA	
	BY	DATE	APP'D.	DATE	JOB NO.	REVISION
DRAWN	TEC	13JAN11	TD	13JAN11	120010	
CHECKED	HD	13JAN11	DSC	13JAN11		
SCALE	1"=65'					
DRAWING NUMBER						
6007-PLN-AGE-00-02-L004						

LIGHTING MITIGATION PLAN FOR TCO - BETA SITE