

DOCKETED

Docket Number:	17-SPPE-01
Project Title:	McLaren Backup Generating Facility
TN #:	222041-9
Document Title:	Application for Small Power Plant Exemption for McLaren Backup Generating Facility - Appendix C Part 2
Description:	N/A
Filer:	Marie Fleming
Organization:	DayZen LLC
Submitter Role:	Applicant Representative
Submission Date:	12/21/2017 4:49:50 PM
Docketed Date:	12/21/2017

**SHEEHAN
NAGLE
HARTRAY
ARCHITECTS**

30 West Monroe, Suite 900
Chicago, IL 60603
o: 312.633.2900
CHICAGO | LONDON

ALFATECH

1321 Ridder Park Dr., Suite 50 (408)487-1200
San Jose, California 95131 www.atce.com

PEOPLES ASSOCIATES

STRUCTURAL ENGINEERS
1996 Tarob Court • Milpitas, CA 95035
408-957-9220 www.pase.com

R+G **RUTH AND GOING, INC.**
Civil Engineering Land Surveying
Planning
2216 THE ALAMEDA SANTA CLARA, CA 95050

oslund.and.assoc.

**LANDSCAPE ARCHITECTURE
MASTER PLANNING
ENVIRONMENTAL DESIGN**

115 WASHINGTON AVE N SUITE 200
MINNEAPOLIS MN 55401
TEL 612.359.9144
www.naala.com

30 WEST MONROE ST.
SUITE 900
CHICAGO, IL 60603
TEL (312) 633-2900 EXT 200

B	GATE ONE REVISION	11-16-2017
A	GATE ONE	10-02-2017
NO.	DESCRIPTION	DATE

PROGRESS SET
NOT FOR CONSTRUCTION

VANTAGE - MCLAREN


625, 725 MATHEW STREET
SANTA CLARA, CA

PRELIMINARY GRADING
AND DRAINAGE PLAN
FULL SITE

DATE: November 16, 2017

SCALE:
AS NOTED

Q311

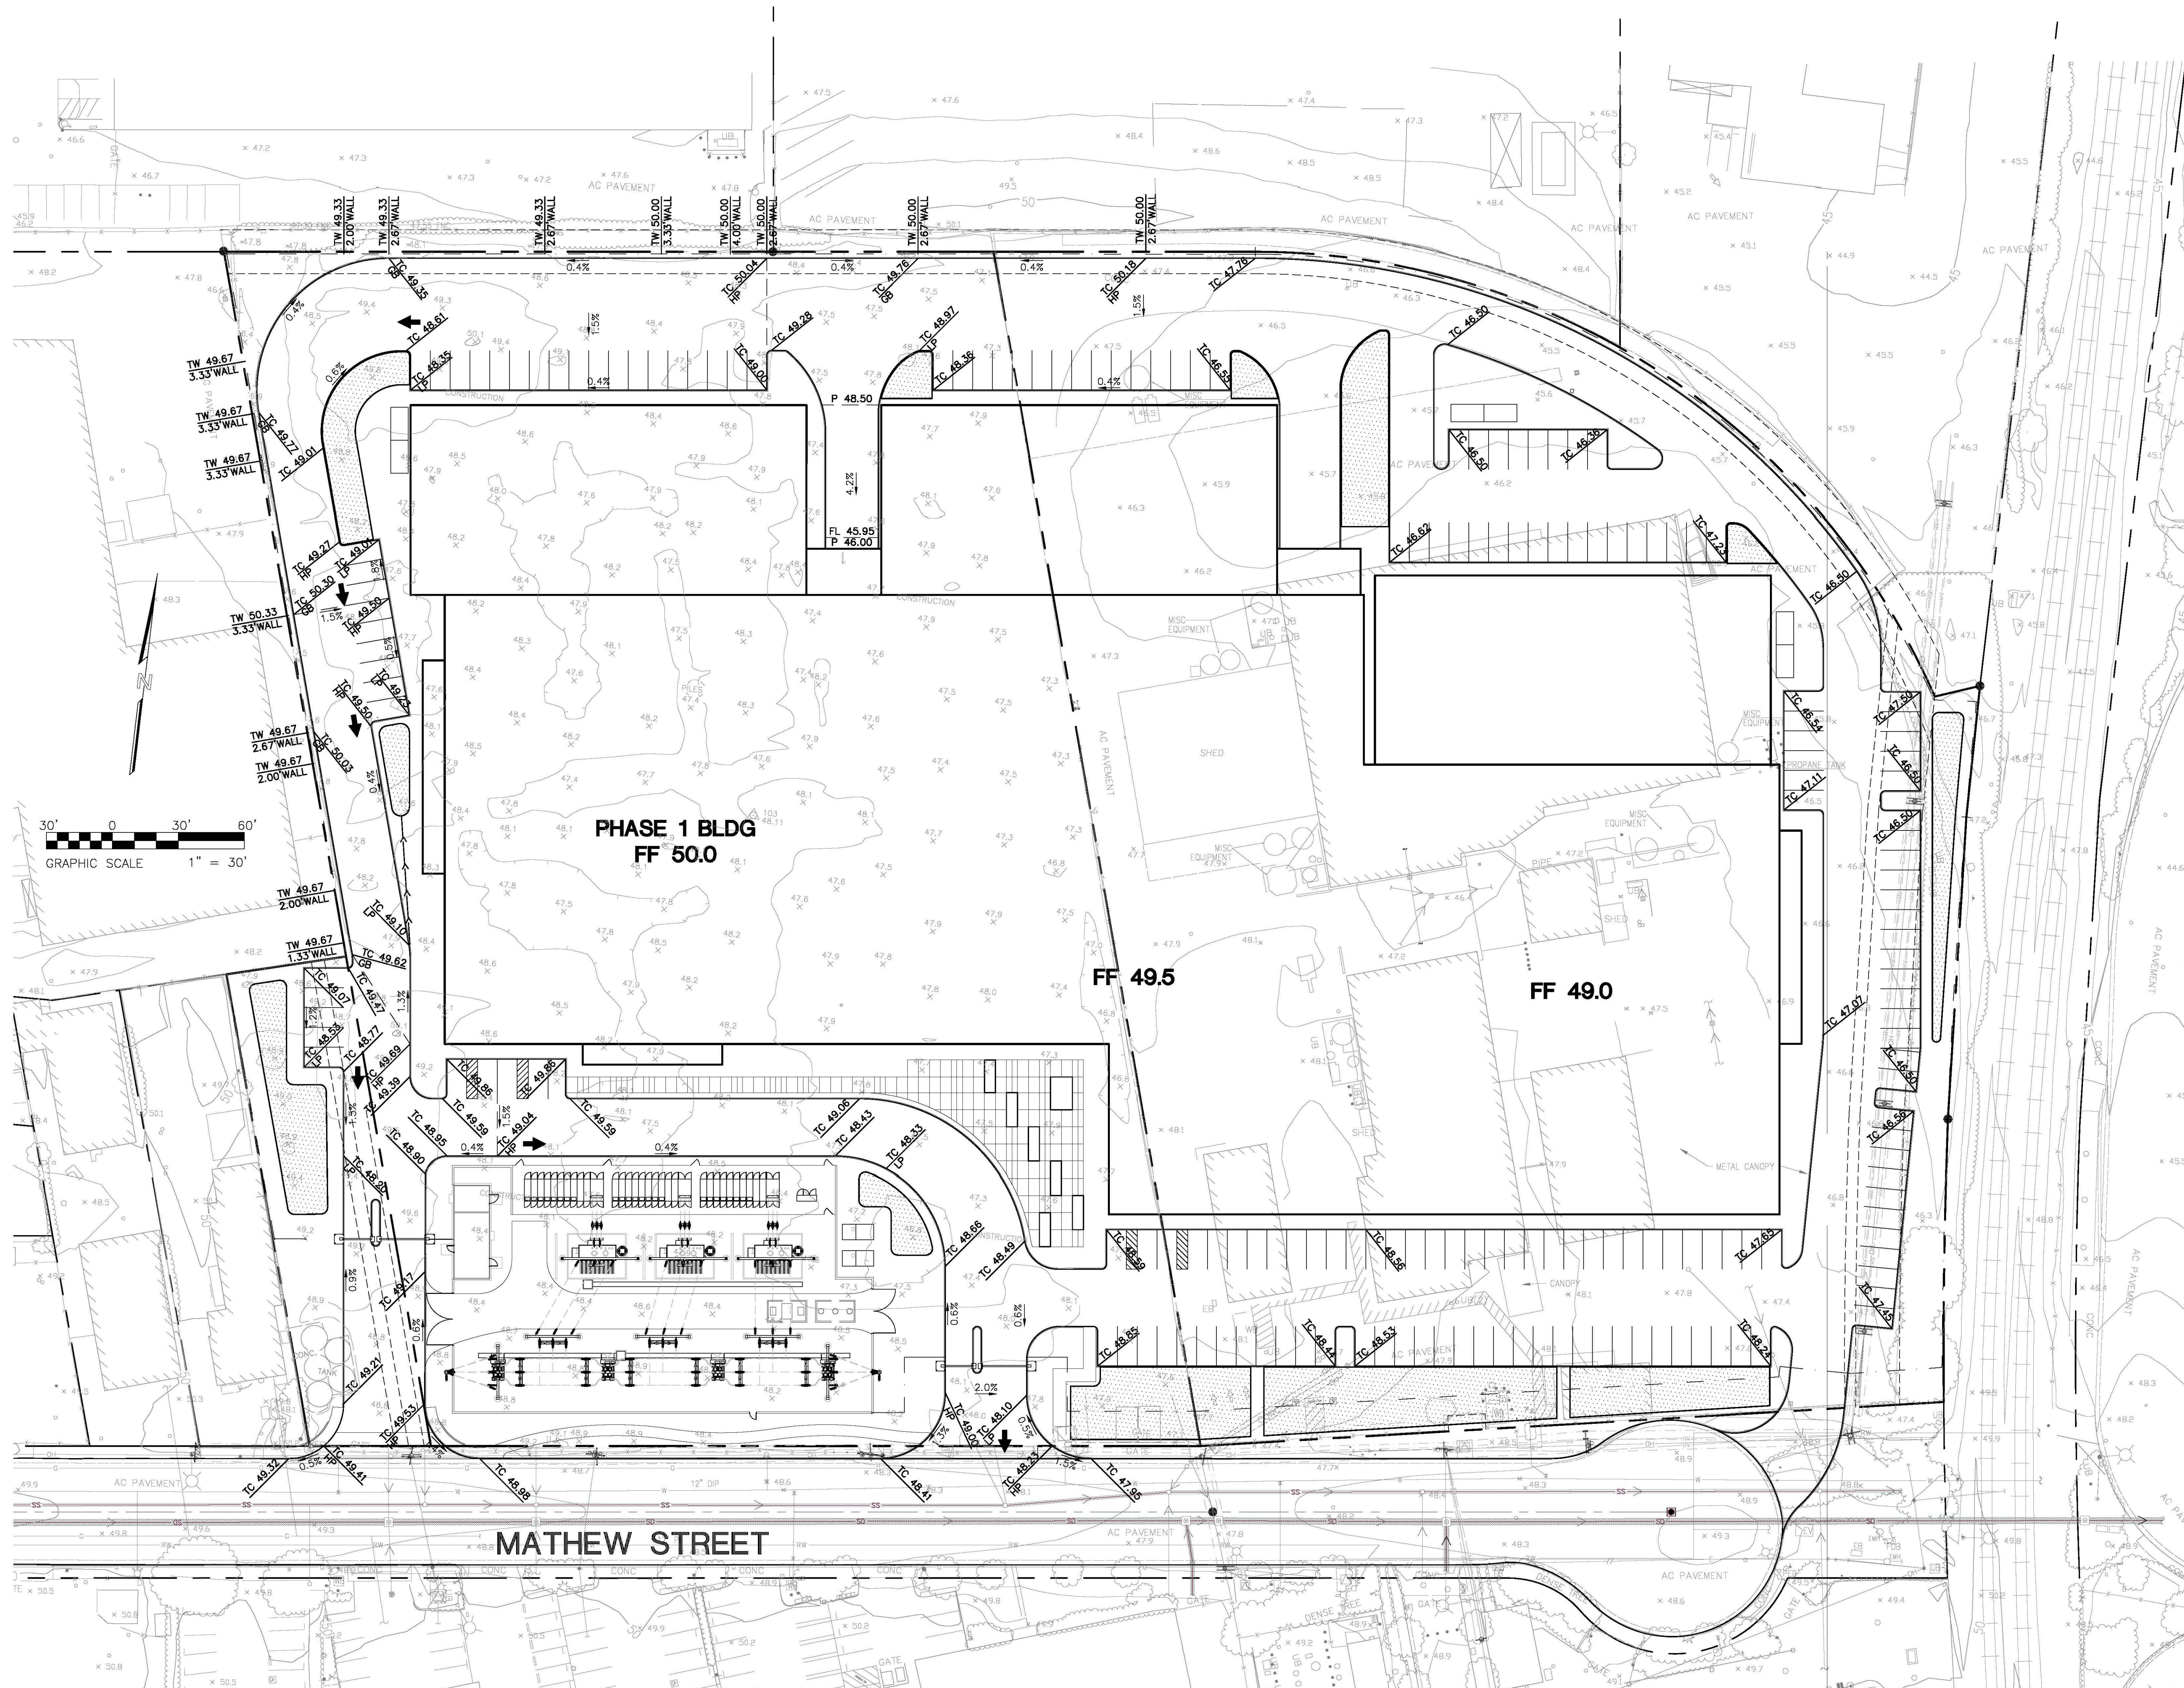

E


D

C

B

A

Drawing file: Q:\Civil\72918A\Draw\Statements\Design\6410 Utility Planning
Nov 13, 2017 - 4:46pm

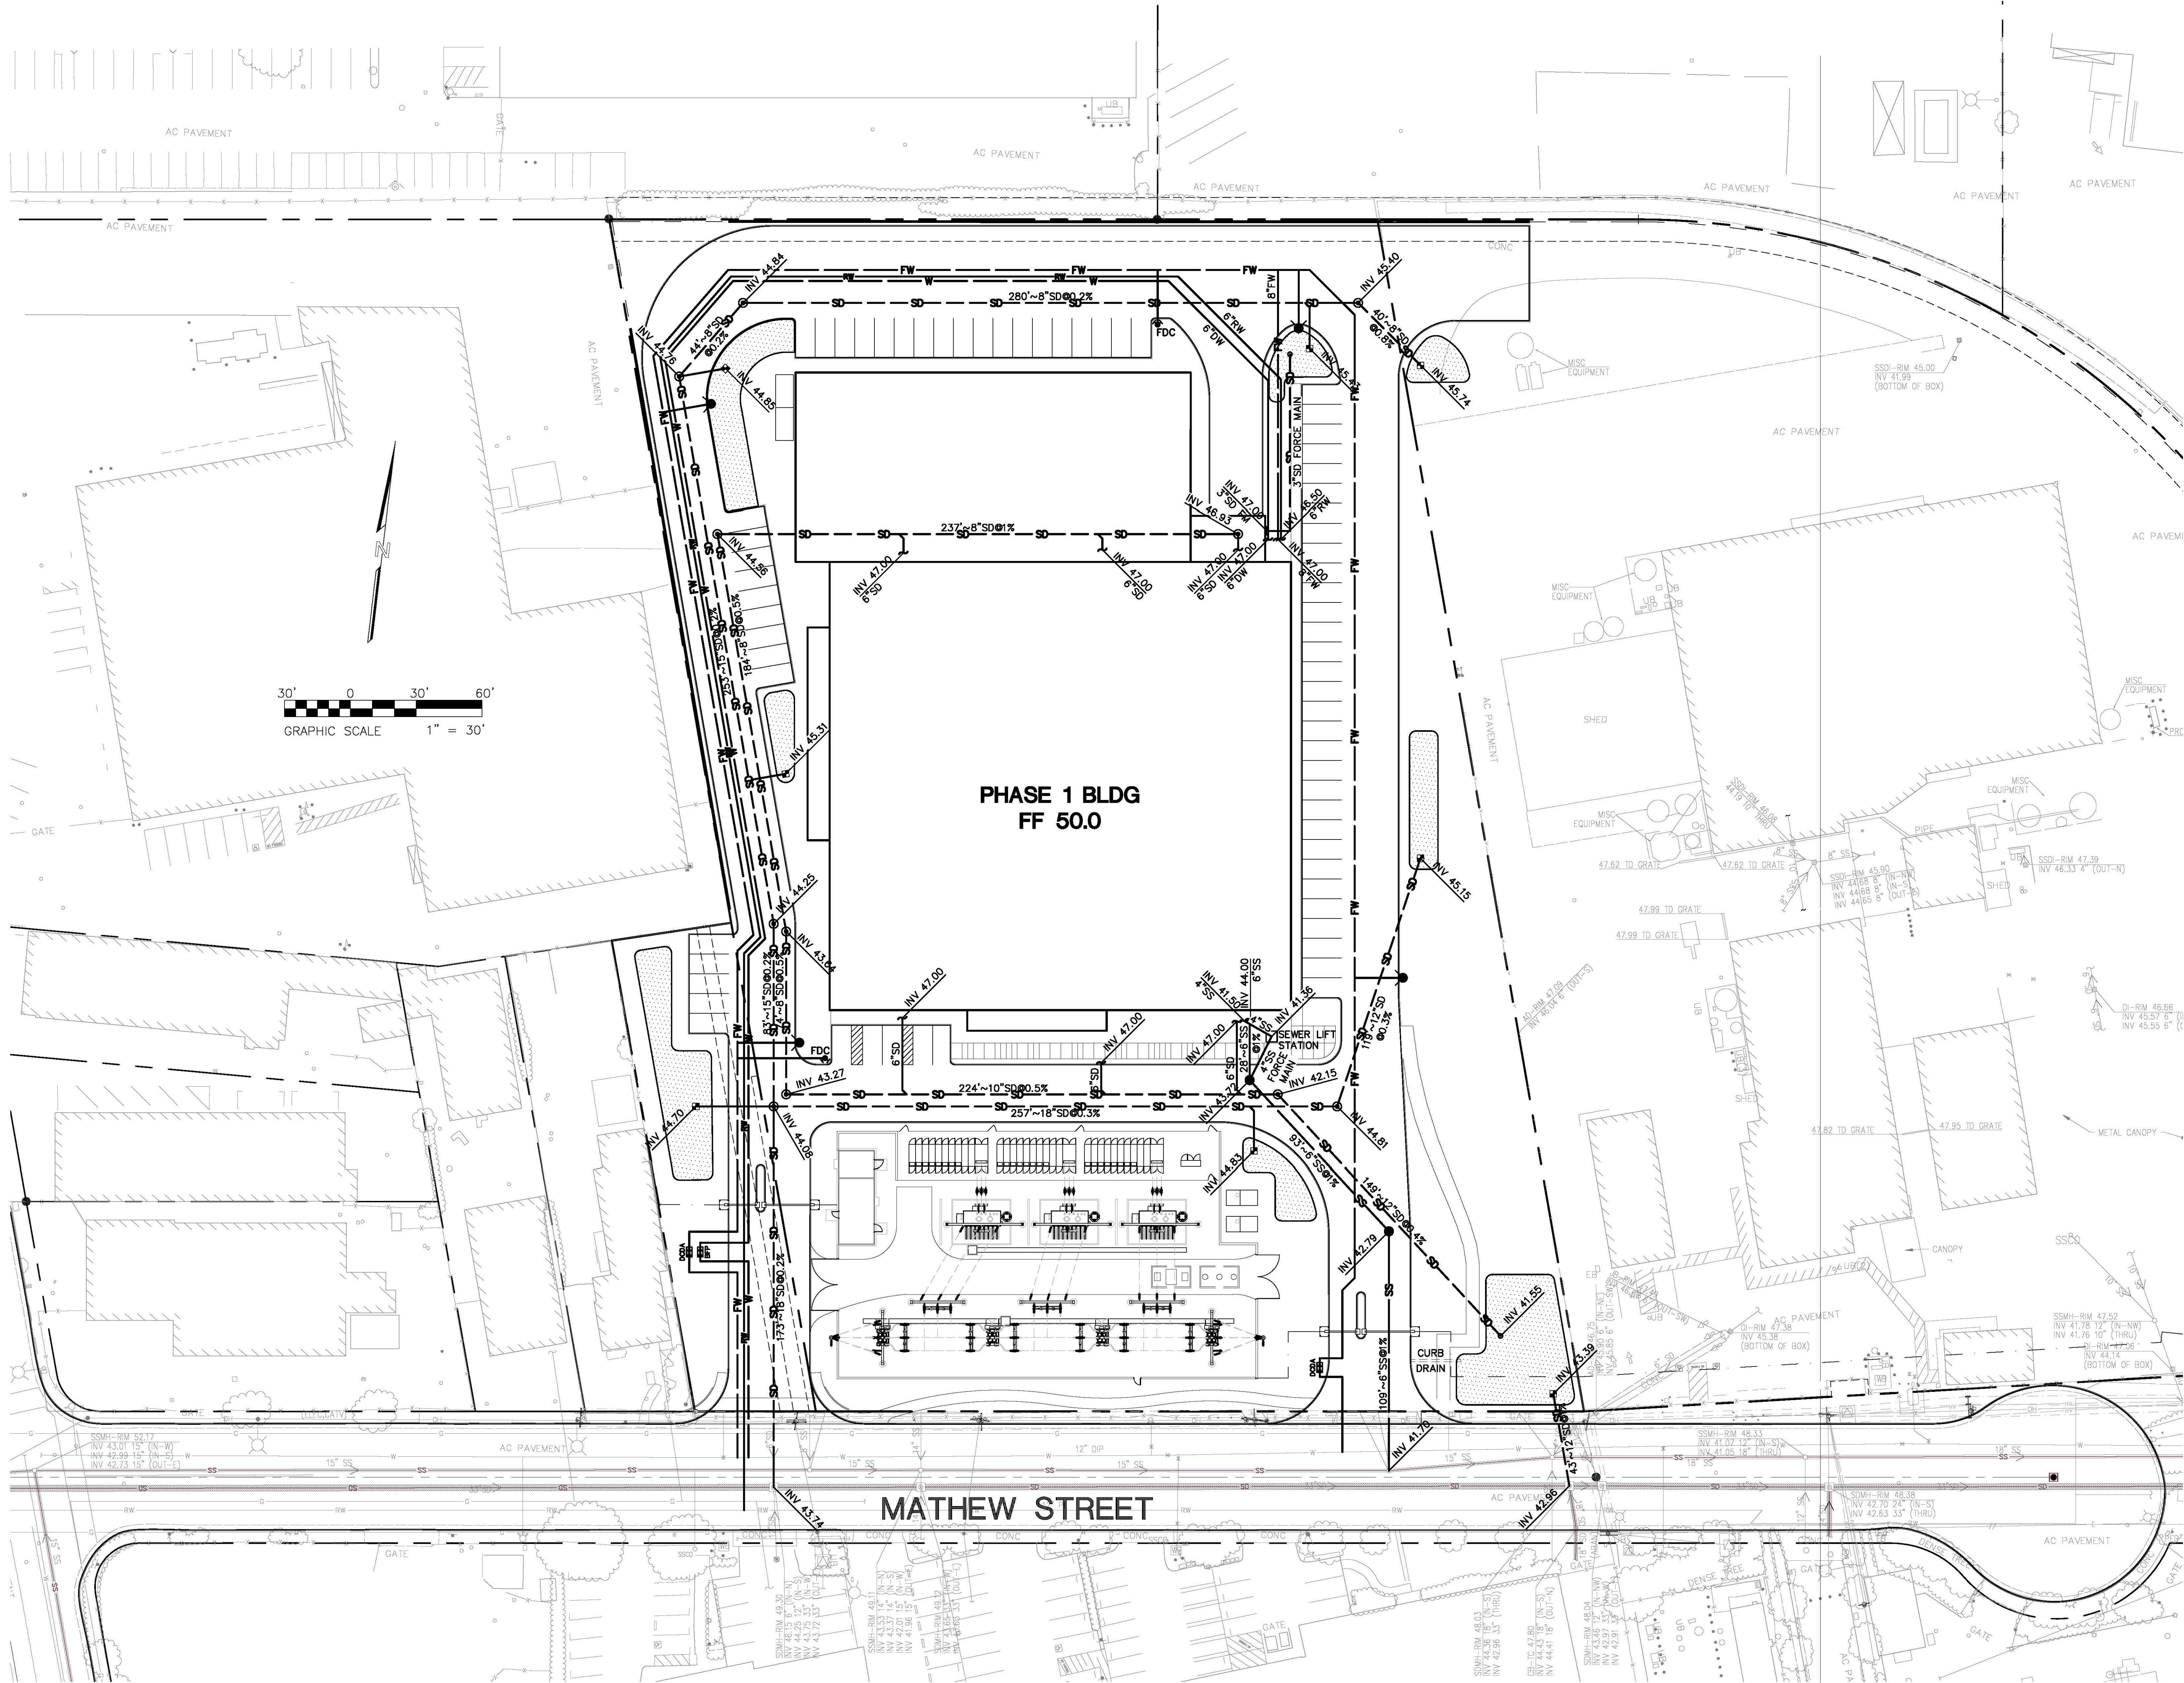

OWNER



ARCHITECT

**SHEEHAN
NAGLE
HARTRAY
ARCHITECTS**

30 West Monroe, Suite 900
Chicago, IL 60603
312.633.2900
CHICAGO | LONDON

MECHANICAL/PLUMBING ENGINEER

ALFATECH

1321 Ridder Park Dr., Suite 50
San Jose, California 95131
(408)487-1200
www.atce.com

STRUCTURAL ENGINEER

**PEOPLES ASSOCIATES
STRUCTURAL ENGINEERS**

1996 Tarob Court
408-957-9220
Milpitas, CA 95035
www.pase.com

CIVIL ENGINEER

R+G RUTH AND GOING, INC.
Civil Engineering Land Surveying
Planning

2216 THE ALAMEDA SANTA CLARA, CA 95050
(408) 236-2400 FAX (408) 236-2410
www.rgaa.com

LANDSCAPE ARCHITECT

oslund.and.assoc.

LANDSCAPE ARCHITECTURE

MASTER PLANNING

ENVIRONMENTAL DESIGN

115 WASHINGTON AVE N

SUITE 200

MINNEAPOLIS MN 55401

TEL 612.359.9144
www.oslund.com

30 WEST MONROE ST.

SUITE 900

CHICAGO, IL 60603

TEL (312) 633-2900 EXT. 141

NO.	DESCRIPTION	DATE
B	GATE ONE REVISION	11-16-2017
A	GATE ONE	10-02-2017
NO.	DESCRIPTION	DATE

DRAWING ISSUES

PROGRESS SET
NOT FOR CONSTRUCTION

PROJECT:

VANTAGE - MCLAREN

Project Status

**625, 725 MATHEW STREET
SANTA CLARA, CA**

DWG. TITLE

**PRELIMINARY UTILITY
PLAN - PHASE 1**

PROJECT NO:

17919A

DATE:

November 16, 2017

SCALE:

AS NOTED

DWG. NO:

C410

© 2017 SHEEHAN PARTNERS, LTO.

E


D

C

B

A

Drawing file: Q:\C411\725\A\DWG\Site\Main.dwg, C411 Utility Planning
Nov 13, 2017 4:45pm

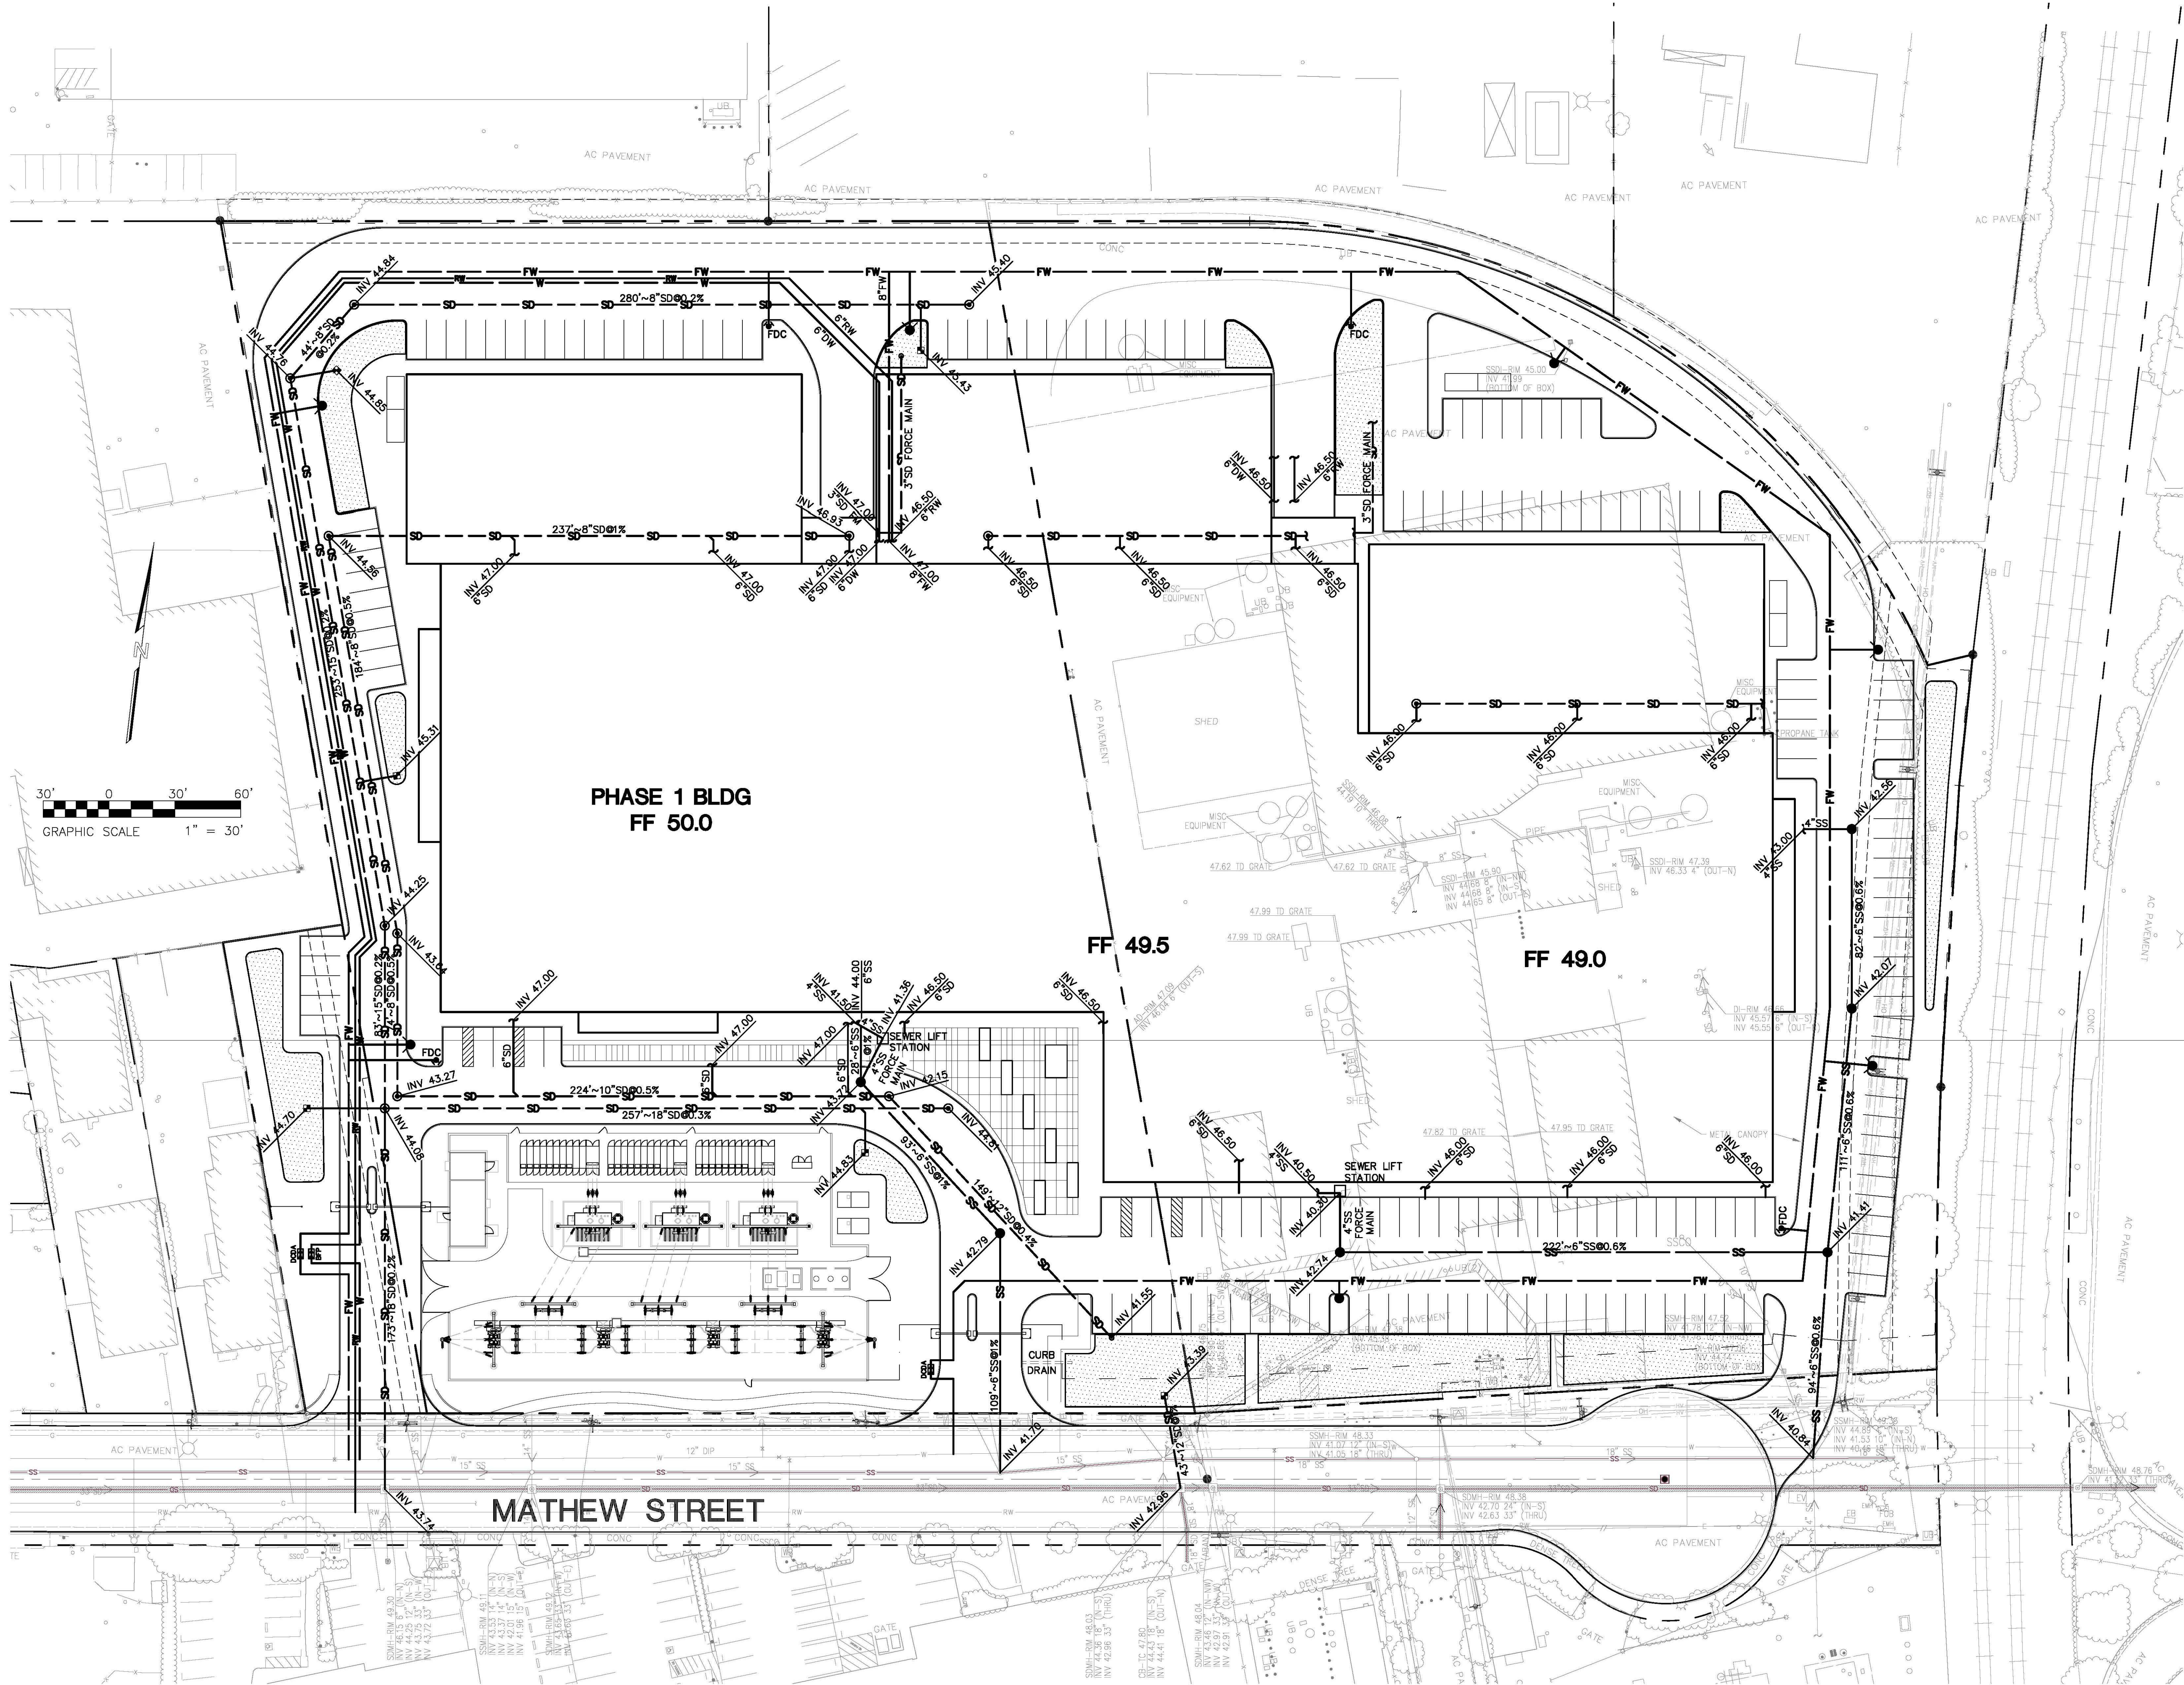

OWNER



ARCHITECT

**SHEEHAN
NABLE
HARTRAY
ARCHITECTS**

30 West Monroe, Suite 900
Chicago, IL 60603
312.633.2900
CHICAGO | LONDON

MECHANICAL/PLUMBING ENGINEER

ALFATECH

1321 Ridder Park Dr., Suite 50 (408)487-1200
San Jose, California 95131 www.alfatech.com

STRUCTURAL ENGINEER

**PEOPLES ASSOCIATES
STRUCTURAL ENGINEERS**

1996 Tarob Court Milpitas, CA 95035
408-957-9220 www.pase.com

CIVIL ENGINEER

R+G RUTH AND GOING, INC.
Civil Engineering Land Surveying
Planning

2216 THE ALAMEDA SANTA CLARA, CA 95050
(408) 236-2400 FAX (408) 236-2410
www.rgusa.com

LANDSCAPE ARCHITECT

oslund.and.assoc.

LANDSCAPE ARCHITECTURE

MASTER PLANNING

ENVIRONMENTAL DESIGN

115 WASHINGTON AVE N

SUITE 200

MINNEAPOLIS MN 55401

TEL 612.359.9144

www.oslund.com

30 WEST MONROE ST.

SUITE 900

CHICAGO, IL 60603

TEL 312.633-2900 EXT. 141

NO.	DESCRIPTION	DATE
B	GATE ONE REVISION	11-16-2017
A	GATE ONE	10-02-2017
NO.	DESCRIPTION	DATE

DRAWING ISSUES

PROGRESS SET
NOT FOR CONSTRUCTION

PROJECT:

VANTAGE - MCLAREN

Project Status

**625, 725 MATHEW STREET
SANTA CLARA, CA**

DWG. TITLE

**PRELIMINARY UTILITY
PLAN - FULL SITE**

PROJECT NO:

17919A

DATE:

November 16, 2017


SCALE:

AS NOTED

DWG. NO:

C411

© 2017 SHEEHAN PARTNERS, LTO.

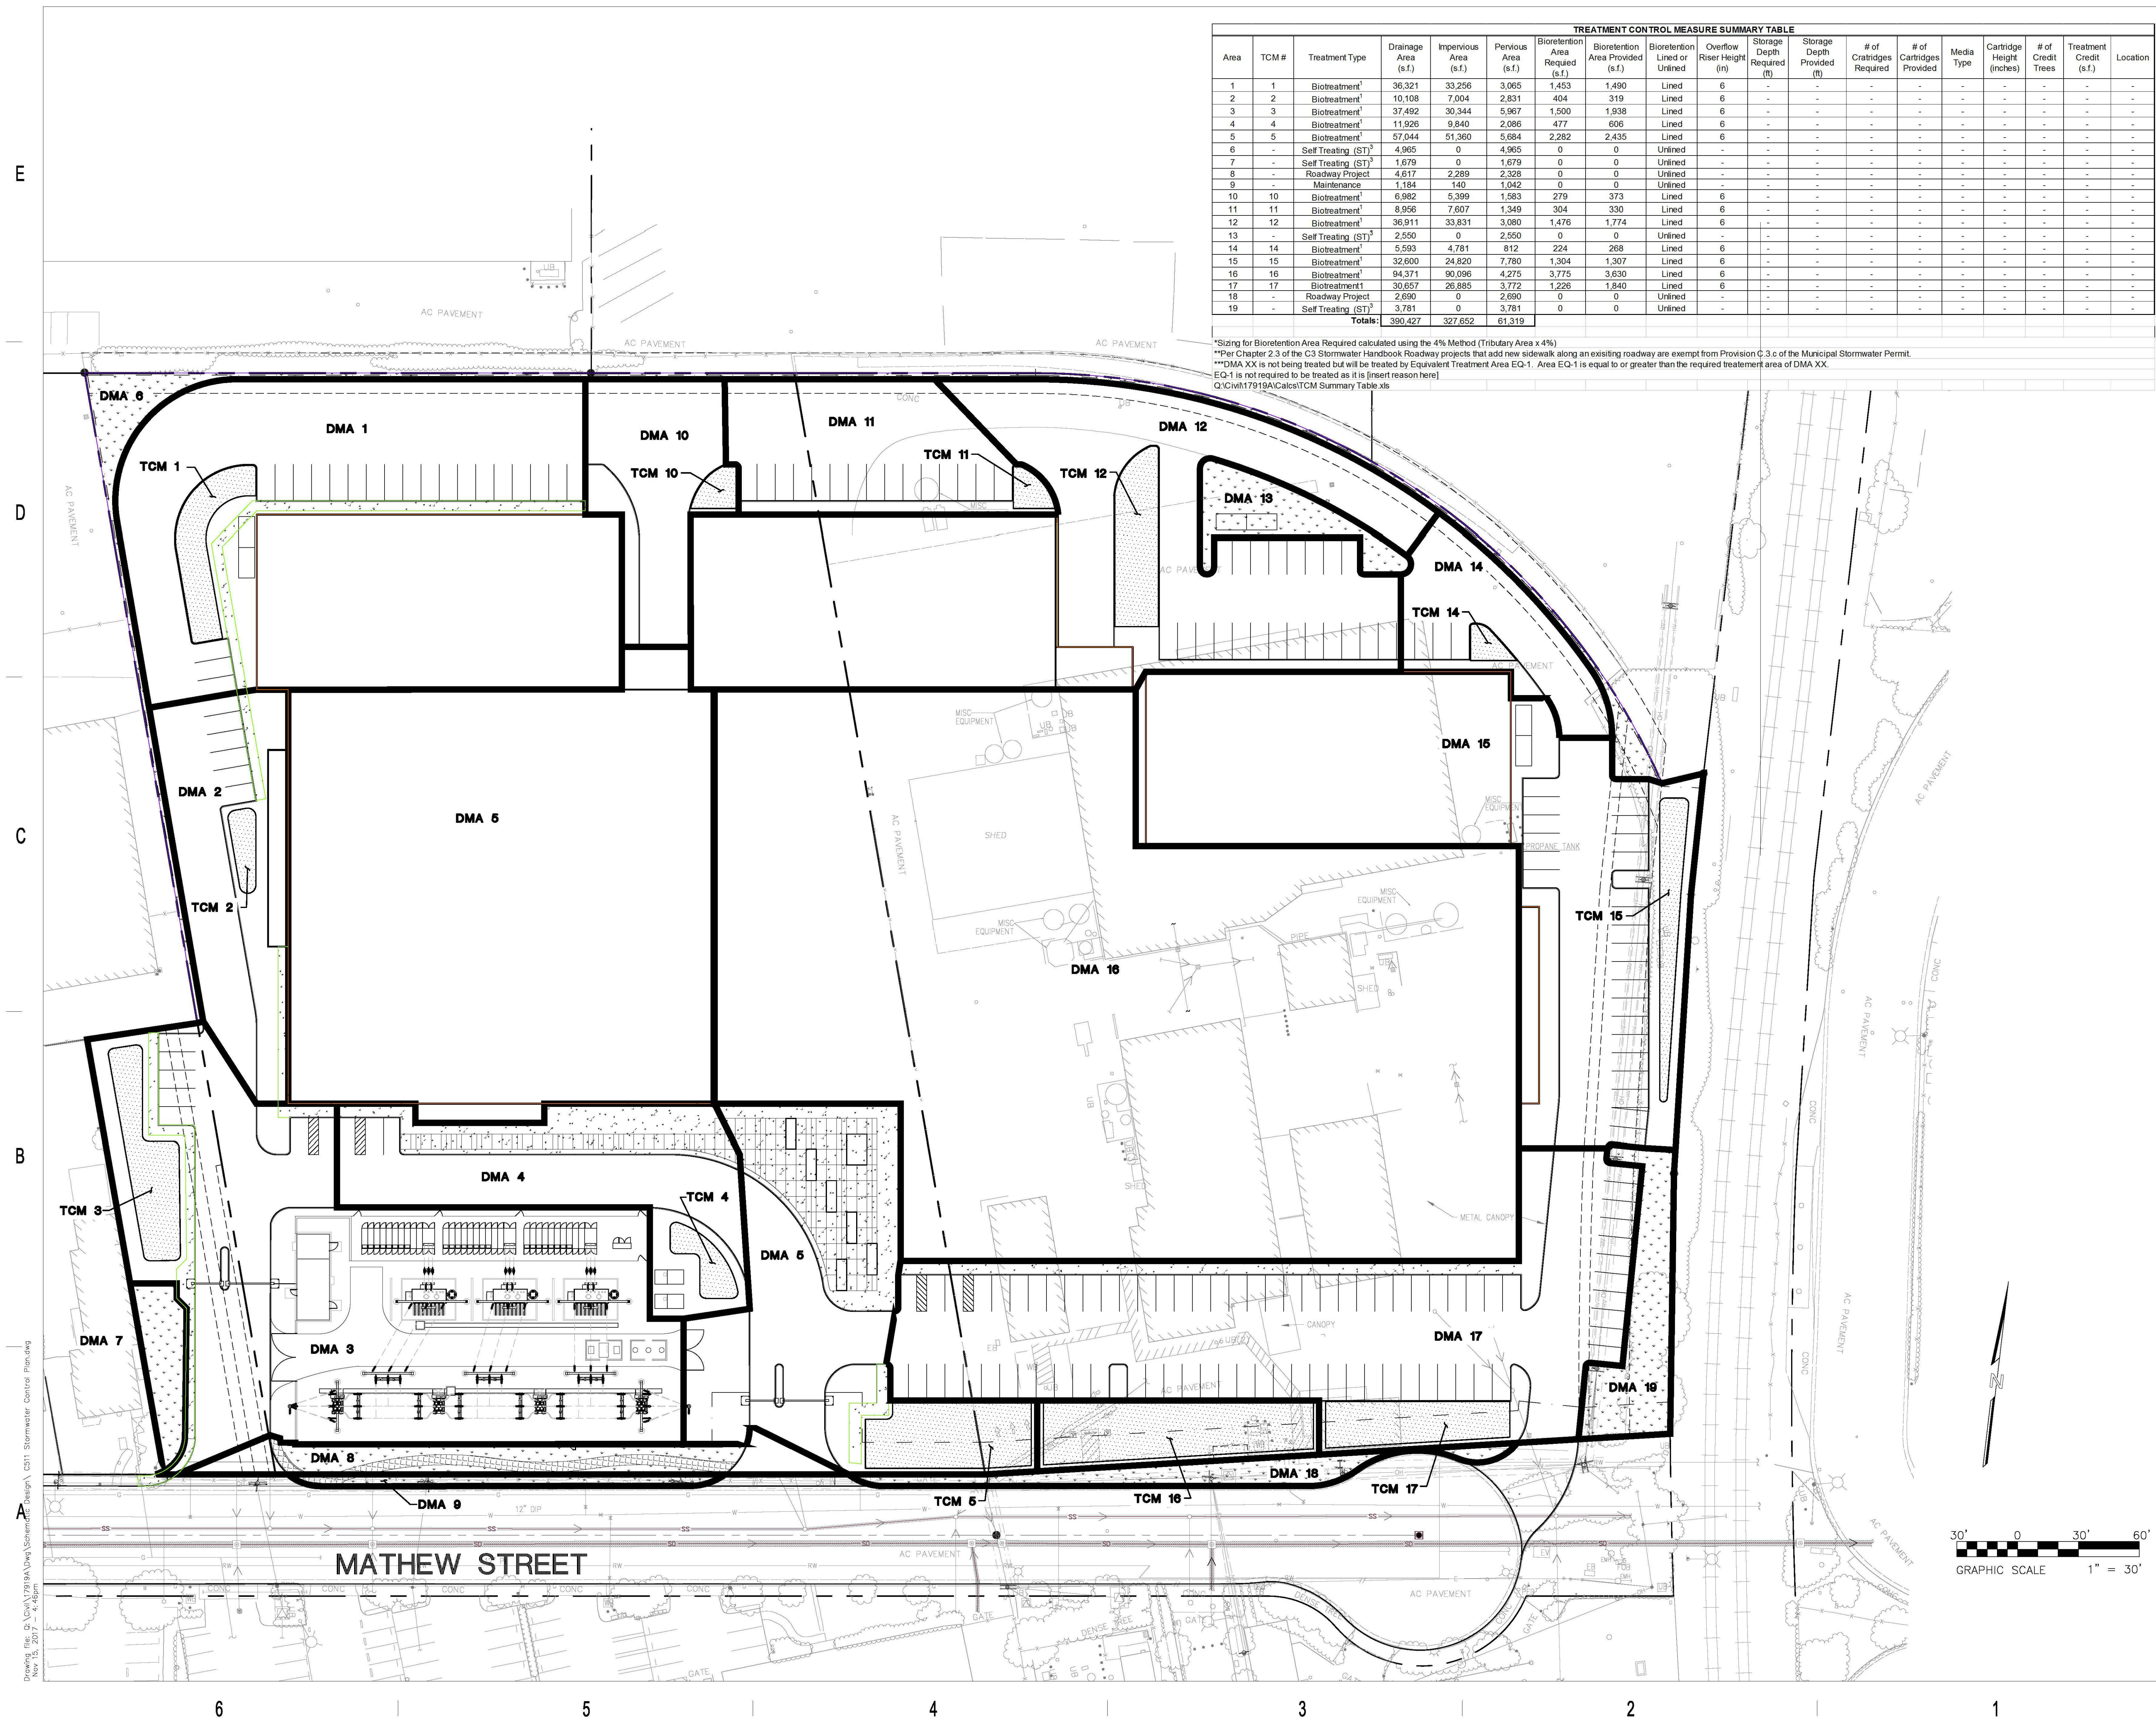[illegible]

*Sizing for Bioretention Area Required calculated using the 4% Method (Tributary Area x 4%)
 **Per Chapter 2.3 of the C3 Stormwater Handbook Roadway projects that add new sidewalk along an existing roadway are exempt from Provision C.3.c of the Municipal Stormwater Permit.
 ***DMA XX is not being treated but will be treated by Equivalent Treatment Area EQ-1. Area EQ-1 is equal to or greater than the required treatment area of DMA XX.
 EQ-1 is not required to be treated as it is [insert reason here]
 Q:\Civil\17919A\Cals\TCM Summary Table.xls

OWNER



ARCHITECT

**SHEEHAN
NAGLE
HARTRAY
ARCHITECTS**

30 West Monroe, Suite 900
Chicago, IL 60603
o: 312.633.2900
CHICAGO | LONDON

MECHANICAL/PLUMBING ENGINEER

ALFATECH

1321 Ridder Park Dr., Suite 50
San Jose, California 95131
(408)487-1200
www.atce.com

STRUCTURAL ENGINEER

PEOPLES ASSOCIATES
STRUCTURAL ENGINEERS

1996 Tarob Court • Milpitas, CA 95035
408-957-9220 www.pase.com

CIVIL ENGINEER

R+G **RUTH AND GOING, INC.**
Civil Engineering Land Surveying
Planning

LANDSCAPE ARCHITECT

oslund.and.assoc.

LANDSCAPE ARCHITECTURE
MASTER PLANNING
ENVIRONMENTAL DESIGN

115 WASHINGTON AVE N
SUITE 200
MINNEAPOLIS MN 55401
TEL 612-359-9144
www.nasla.com

30 WEST MONROE ST.
SUITE 900
CHICAGO, IL 60603
TEL (312) 633-2900 EXT. 141

DRAWING ISSUES

PROGRESS SET
NOT FOR CONSTRUCTION

PROJECT:

VANTAGE - MCLAREN

Project Status

**625, 725 MATHEW STREET
SANTA CLARA, CA**

DWG. TITLE

PRELIMINARY
STORMWATER CONTROL
PLAN - FULL SITE

PROJECT NO: 17919A

DATE: November 16, 2017

SCALE:

AS NOTED

DWG. NO.:

CE 1.1

© 2017 SHEEHAN PARTNERS, LTD.

